

 


BAHURATNA VASUNDHARA, GUJARAT UNIVERSITY

TENDER DRAWING SET



APICES STUDIO PVT. LTD.
 203,204,205, LODHA SUPREMUS,
 ROAD NO.22,WAGALE ESTATE,
 THANE WEST - 400604
 TEL: +91 22 25870701/702/703/704

		0.0.0	
GENERAL NOTES: ALL DIMENSIONS SHOWN ARE IN MILLIMETERS ALL SURFACE LEVELS ARE SHOWN IN METERS THIS DRAWING SHALL NOT BE SCALED. WRITTEN DIMENSIONS SHALL BE FOLLOWED. DISCREPANCIES BETWEEN SITE CONDITION AND DATA SHOWN ON DRAWING SHALL BE BROUGHT TO THE NOTICE OF THE ARCHITECT PRIOR TO CONSTRUCTION WORKS.			
DRAWING NOTES: THE INFORMATION ON THIS DRAWING SUPERCEDES INFORMATION IN OTHER DRAWINGS			
KEY PLAN :			
REV NO.	REVISION DETAILS	DATE	
REVISION NOTES			
CONSULTANTS:			
STRUCTURAL CONSULTANT :  Associated Structural Engineers LLP. 607, Opal Square, Opp. Ralladevi Lake, Barve Rd. Wagale Estate, Thane (W) - 400 604. Phone: +91-22-25812584/45, 8976072223 Email: info@asc.org.in Website: www.asc.org.in			
MEP CONSULTANT : M/s. Specialised Mep Engineering Consultants. Thane - West Email : specialisedmepconsultants@gmail.com			
SCALE: 1:150	DRAWN BY SHRADDHA		
PAPER A2	CHECKED BY KALYANI		
DATE 17-10-2024	DRAWING TYPE : TENDER DRAWING		
DRAWING NAME:	INDEX AND SCHEDULES		
REVISION NUMBER:	R0		
PROJECT NAME:	BAHURATNA VASUNDHARA - GUJARAT UNIVERSITY		
PROJECT NUMBER:			
ARCHITECT:	APICES STUDIO PVT. LTD.		
CLIENT NAME:	GUJARAT UNIVERSITY		
 APICES STUDIO PVT. LTD. 203,204,205,LODHA SUPREMUS, ROAD NO.22,WAGALE ESTATE, THANE WEST - 400604 TEL: +91 22 25870701/702/703/704			

BAHURATNA VASUNDHARA	
LIST OF DRAWINGS	
DWG. NO.	DRAWING TITLE
100	SITE RELATED
APS-BV-A-101-R0	SITE PLAN
200	FLOOR PLANS
APS-BV-A-201-R0	GROUND FLOOR PLAN
APS-BV-A-202-R0	FIRST FLOOR PLAN
APS-BV-A-203-R0	SECOND FLOOR PLAN
APS-BV-A-204-R0	ROOF PLAN
300	SECTIONS & WALL SECTIONS
APS-BV-A-301-R0	SECTION AA
APS-BV-A-302-R0	SECTION BB
APS-BV-A-303-R0	SECTION CC
APS-BV-A-303-R0	SECTION DD
400	ELEVATIONS
APS-BV-A-401-R0	INTERNAL COURT ELEVATION
APS-BV-A-402-R0	OUTER ELEVATION
APS-BV-A-403-R0	SIDE ELEVATION (WEST)
APS-BV-A-404-R0	SIDE ELEVATION (EAST)
500	STAIRCASE AND RAMPS
APS-BV-A-501-R0	STAIRCASE-1 DETAIL
APS-BV-A-502-R0	RAMP - 1 DETAIL
APS-BV-A-503-R0	
600	DOORS AND WINDOWS
APS-BV-A-601-R0	DOOR DETAILS
APS-BV-A-602-R0	DOOR DETAILS
APS-BV-A-603-R0	WINDOW DETAILS
APS-BV-A-604-R0	WINDOW DETAILS
APS-BV-A-605-R0	GLAZING DETAILS
700	ELECTRICAL PLANS
APS-BV-A-701-R0	GROUND FLOOR PLAN
APS-BV-A-702-R0	FIRST FLOOR PLAN
APS-BV-A-703-R0	SECOND FLOOR PLAN
800	DETAILS - CIVIL
APS-BV-A-801-R0	COLUMN DETAILS
APS-BV-A-802-R0	COLUMN DETAILS
APS-BV-A-803-R0	ARCH DETAILS
APS-BV-A-804-R0	ARCH DETAILS
APS-BV-A-805-R0	BALUSTER DETAILS
APS-BV-A-806-R0	AMPHITHEATRE DETAILS
APS-BV-A-807-R0	DOME DETAILS
APS-BV-A-808-R0	WATER BODY DETAILS
APS-BV-A-809-R0	TICKET COUNTER DETAILS
APS-BV-A-810-R0	
900	FINISHING DETAILS
APS-BV-A-901-R0	FLOORING DETAILS - GALLERY
APS-BV-A-902-R0	FLOORING DETAILS - KIOSK
APS-BV-A-903-R0	FLOORING DETAILS - RAMP
APS-BV-A-904-R0	FLOORING DETAILS - AMPHITHEATRE
APS-BV-A-905-R0	FLOORING DETAILS - OPEN COURT
APS-BV-A-906-R0	CLADDING DETAILS
APS-BV-A-907-R0	
APS-BV-A-908-R0	GATEHOUSE DETAILS
APS-BV-A-909-R0	CURB DETAILS

	STRUCTURAL
APS-BV-ST-1001-R0	GROUND FLOOR PLAN
APS-BV-ST-1002-R0	RAMP PLAN
APS-BV-ST-1003-R0	FIRST FLOOR PLAN
APS-BV-ST-1004-R0	VIEWING GALLERY PLAN
APS-BV-ST-1005-R0	FOOTING LEVEL PLAN
APS-BV-ST-1006-R0	FOOTING DETAILS
	MEP
APS-BV-MEP-2001-R0	GROUND FLOOR PLAN-SWD
APS-BV-MEP-2002-R0	FIRST & SECOND FLOOR PLAN - PHE
APS-BV-MEP-2003-R0	HVAC
APS-BV-MEP-2004-R0	GROUND FLOOR-ELECTRICAL
APS-BV-MEP-2005-R0	1ST 2ND FLOOR-ELECTRICAL
APS-BV-MEP-2006-R0	SITE PLAN-ELECTRICAL
APS-BV-MEP-2007-R0	GROUND FLOOR PLAN-ELV.
APS-BV-MEP-2008-R0	FIRST & SECOND - ELV.
APS-BV-MEP-2009-R0	CCTVGROUND FLOOR
APS-BV-MEP-2010-R0	CCTVFIRST & SECOND FLOOR
APS-BV-MEP-2011-R0	FAPA & ELECTRICAL - GROUND
APS-BV-MEP-2012-R0	FAPA & ELECTRICAL - FIRST
APS-BV-MEP-2013-R0	FAPA & ELECTRICAL - SECOND & ROOF

DISCREPANCIES BETWEEN SITE CONDITION AND
DATA SHOWN ON DRAWING SHALL BE
BROUGHT TO THE NOTICE OF THE ARCHITECT
PRIOR TO CONSTRUCTION WORKS.

KEY PLAN :

REVISION NOTES

STRUCTURAL CONSULTANT : **Associated Structural Engineers LLP.**
607, Opal Square, Opp. Railadevi Lake, Barve Rd. Wagale Estate
Thane (w)- 400 604.
Phone: +91-22-20812084/85, 8976072223
Email: info@asc.org.in Website: www.asc.org.in

L

APICES
studio pvt. ltd.

APICES STUDIO PVT. LTD.
203,204,205,LODHA SUPREMUS,
ROAD NO.22,WAGALE ESTATE,
THANE WEST - 400604
TEL: +91 22 25870701/702/703/704

GENERAL NOTES:
ALL DIMENSIONS SHOWN ARE IN MILLIMETERS
ALL SURFACE LEVELS ARE SHOWN IN METERS
THIS DRAWING SHALL NOT BE SCALED.
WRITTEN DIMENSIONS SHALL BE FOLLOWED.

DISCREPANCIES BETWEEN SITE CONDITION AND DATA SHOWN ON DRAWING SHALL BE BROUGHT TO THE NOTICE OF THE ARCHITECT PRIOR TO CONSTRUCTION WORKS.

DRAWING NOTES:
1. THE INFORMATION ON THIS DRAWING SUPERCEDES INFORMATION IN OTHER DRAWINGS.
2. ALL THE EXISTING TREES NEED TO BE RETAIN AND TRIMMED.

KEY PLAN :

REV NO.	REVISION DETAILS	DATE

REVISION NOTES

CONSULTANTS:

STRUCTURAL CONSULTANT :  Associated Structural Engineers LLP.
607, Opal Square, Opp. Palladevi Lake, Barve Rd. Wagale Estate, Thane (w) - 400 604.
Phone: +91-22-25812084/85, 8876072223
Email: info@asc.org.in Website: www.asc.org.in

MEP CONSULTANT :
M/s. Specialised Mep Engineering Consultants.
Thane - West
Email : specialisedmepconsultants@gmail.com


SCALE: 1:150	DRAWN BY SHRADDHA		
PAPER A2	CHECKED BY KALYANI		
DATE 17-10-2024	DRAWING TYPE : TENDER DRAWING		
DRAWING NAME:	GROUND FLOOR PLAN		
REVISION NUMBER:	R0		
PROJECT NAME:	BAHURATNA VASUNDHARA - GUJARAT UNIVERSITY		
PROJECT NUMBER:			
ARCHITECT:	APICES STUDIO PVT. LTD.		
CLIENT NAME:	GUJARAT UNIVERSITY		

PROJECT ARCHITECTS



APICES STUDIO PVT. LTD.
203,204,205,LODHA SUPREMUS,
ROAD NO.22,WAGALE ESTATE,
THANE WEST - 400604
TEL: +91 22 25870701/702/703/704

SR. NO.	DOOR/ WINDOW NO.	SILL	LINTEL	SIZE	LOCATION	DISCRPTION
1	D1	300MM	2400MM	900X2100	STORE, KITCHEN, ADMIN, TICKET	WOODEN FLUSHED DOOR
2	D2	0	2400MM	2200X2400	GALLERY	WOODEN FLUSHED DOOR
3	GD1	150MM	2550MM	2560X2400	SOUVENIR SHO	GLAZED OPENABLE DOOR
4	D3	0	3500MM	3000X3500	GALLERY	SLIDING PANEL DOOR
5	G1	0	2300MM	2560X2400	SOUVENIR SHOP	FIXED GLAZING
6	G2	125MM	2900MM	2550X2775	GALLERY	FIXED GLAZING
7	W1	1000MM	2500MM	2935X1500	TICKET COUNTER	GLAZING WINDOW
8	W2	1000MM	2500MM	1200X1500	ADMIN	GLAZING WINDOW

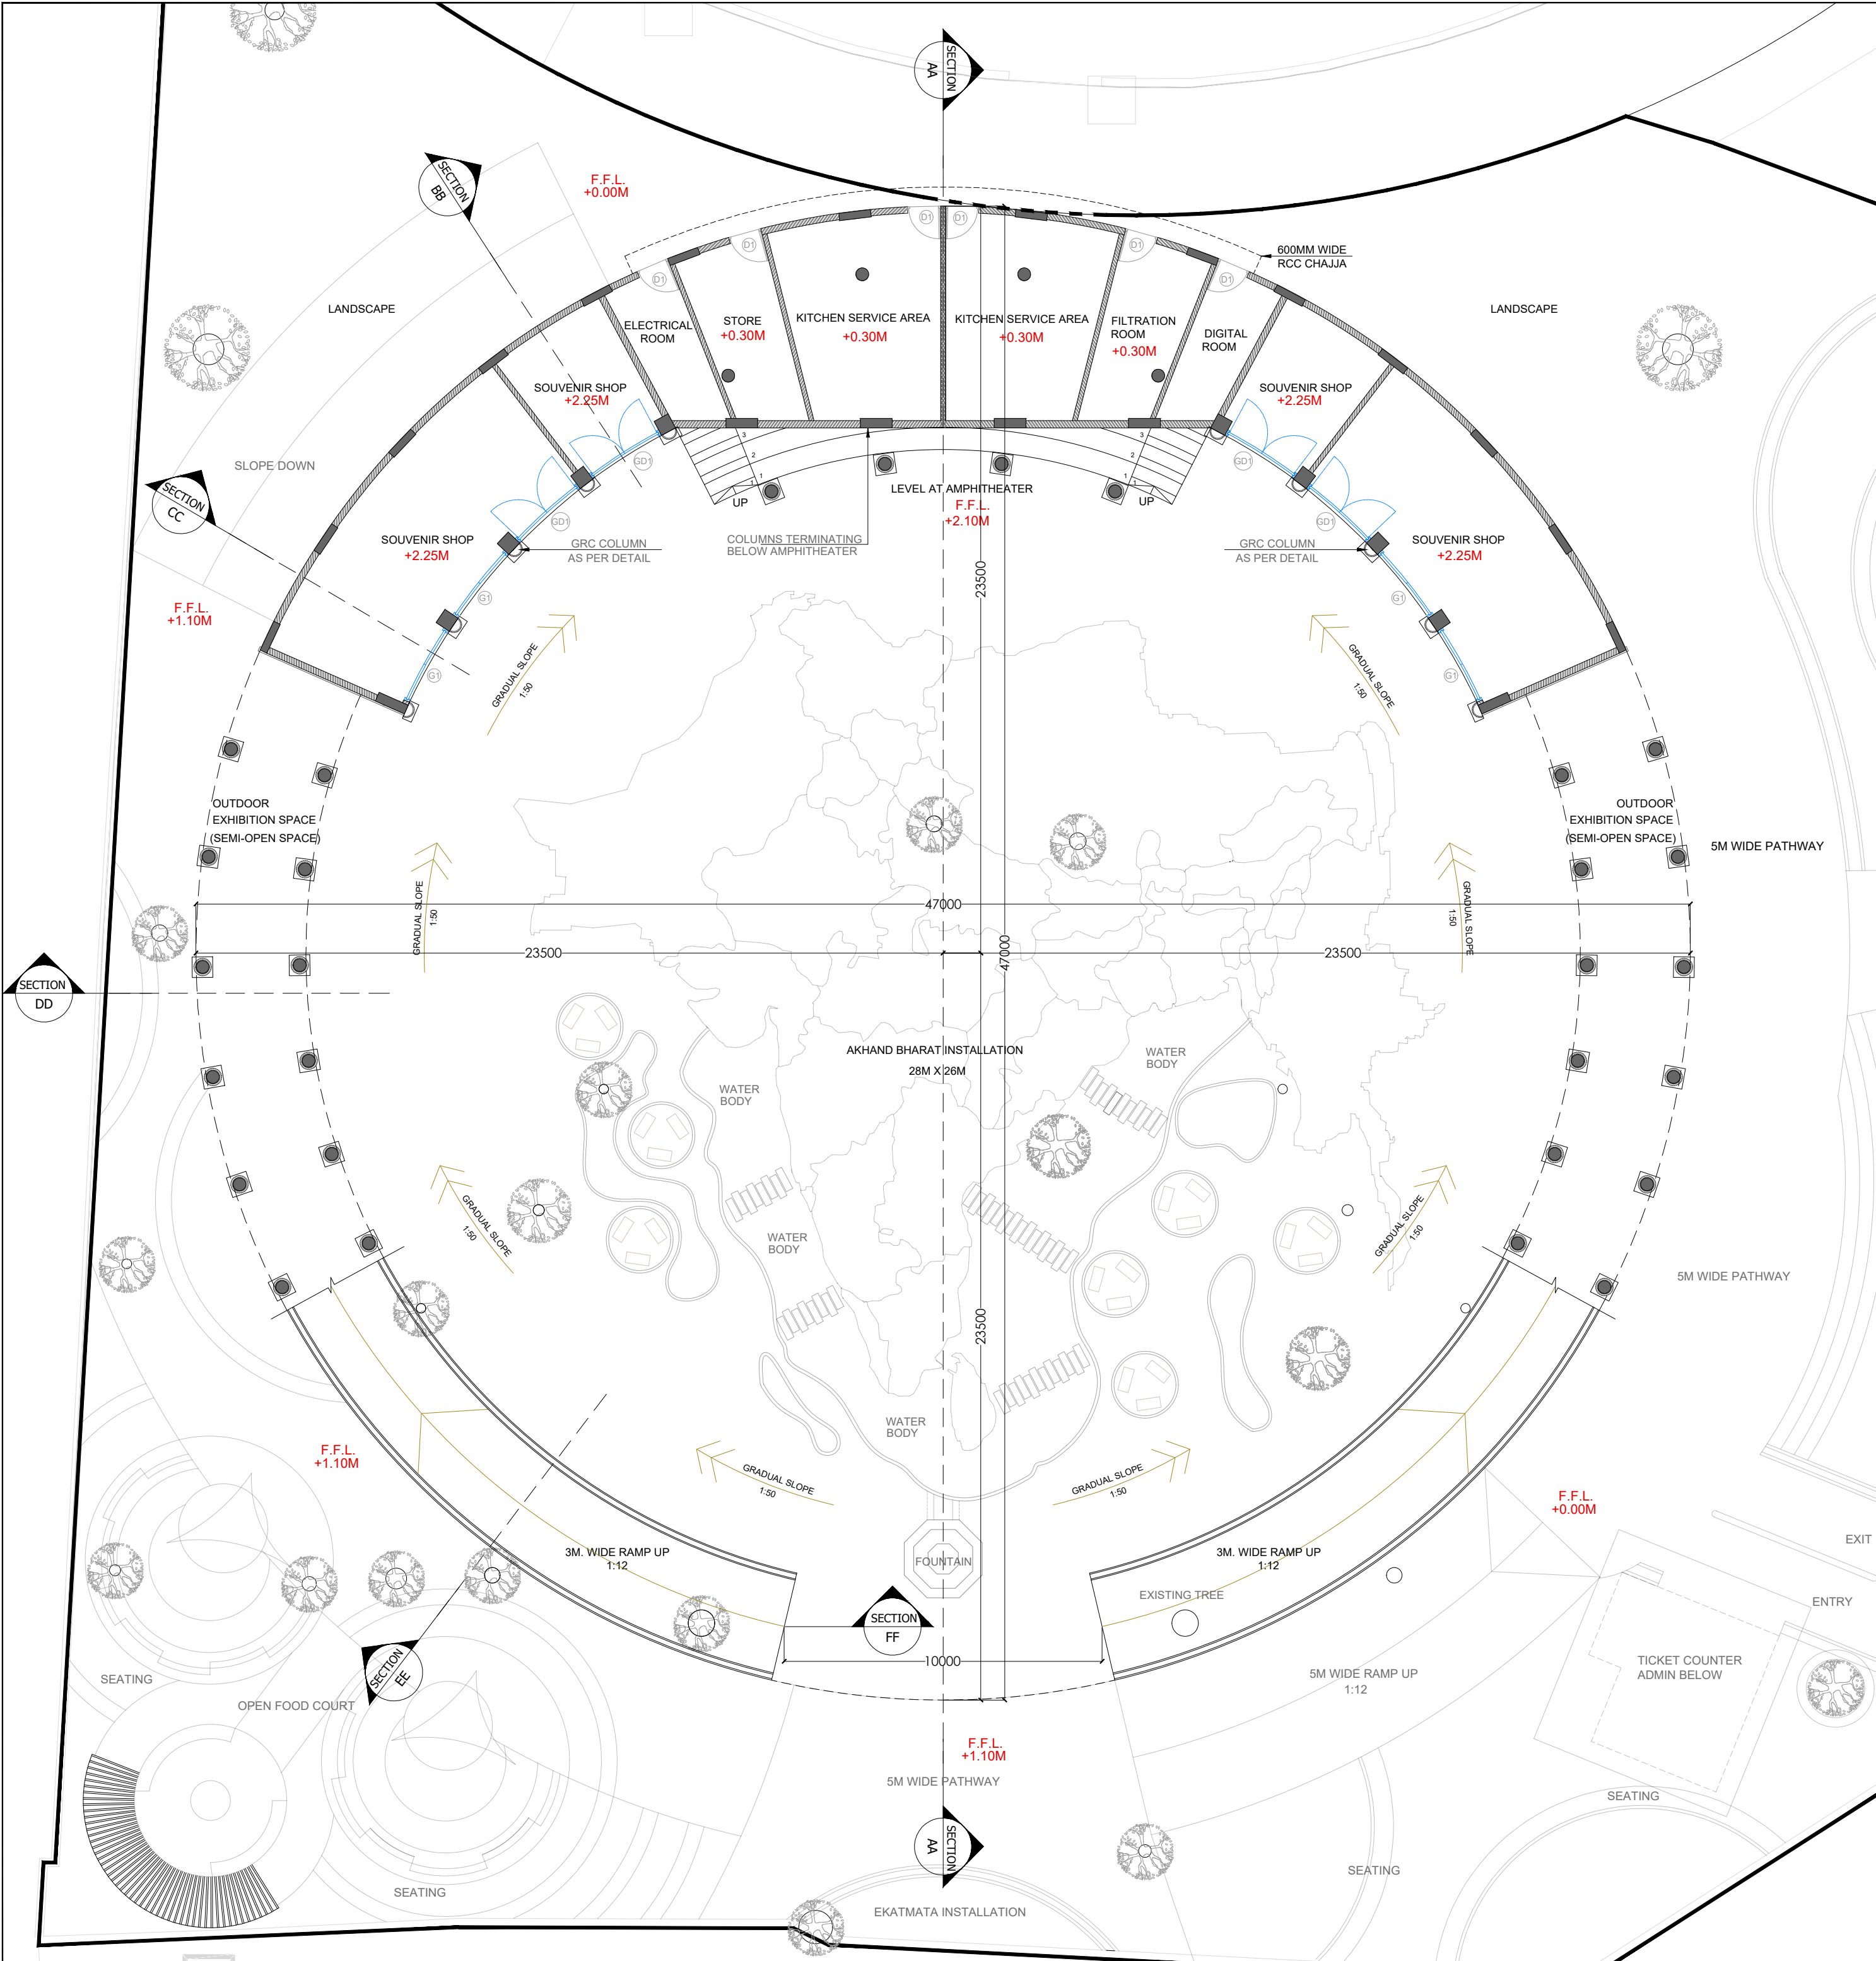

GENERAL NOTES:
ALL DIMENSIONS SHOWN ARE IN MILLIMETERS
ALL SURFACE LEVELS ARE SHOWN IN METERS
THIS DRAWING SHALL NOT BE SCALED.
WRITTEN DIMENSIONS SHALL BE FOLLOWED.

DISCREPANCIES BETWEEN SITE CONDITION AND DATA SHOWN ON DRAWING SHALL BE BROUGHT TO THE NOTICE OF THE ARCHITECT PRIOR TO CONSTRUCTION WORKS.

DRAWING NOTES:
1. THE INFORMATION ON THIS DRAWING SUPERCEDES INFORMATION IN OTHER DRAWINGS.
2. ALL THE EXISTING TREES NEED TO BE RETAIN AND TRIMMED.

KEY PLAN :


REV NO.	REVISION DETAILS	DATE

REVISION NOTES

CONSULTANTS:

STRUCTURAL CONSULTANT :  Associated Structural Engineers LLP.
Thane (w)- 400 604.
607, Opal Square, Opp. Palladevi Lake, Barve Rd. Wagale Estate,
Phone: +91-22-20812084/85, 8876072223
Email: info@asc.org.in Website: www.asc.org.in

 MEP CONSULTANT :
M/s. Specialised Mep
Engineering Consultants.
Thane - West
Email : specialisedmepconsultants@gmail.com


SCALE: 1:150	DRAWN BY SHRADDHA	
PAPER A2	CHECKED BY KALYANI	
DATE 17-10-2024	DRAWING TYPE : TENDER DRAWING	
DRAWING NAME:	FIRST FLOOR PLAN	
REVISION NUMBER:	R0	
PROJECT NAME:	BAHURATNA VASUNDHARA - GUJARAT UNIVERSITY	
PROJECT NUMBER:		
ARCHITECT:	APICES STUDIO PVT. LTD.	
CLIENT NAME:	GUJARAT UNIVERSITY	


PROJECT ARCHITECTS



APICES STUDIO PVT. LTD.
203,204,205,LODHA SUPREMUS,
ROAD NO.22,WAGALE ESTATE,
THANE WEST - 400604
TEL: +91 22 25870701/702/703/704

SR. NO.	DOOR/ WINDOW NO.	SILL	UNTEL	SIZE	LOCATION	DISCRPTION
1	D1	300MM	2400MM	900X2100	STORE, KITCHEN, ADMIN, TICKET	WOODEN FLUSHED DOOR
2	D2	0	2400MM	2200X2400	GALLERY	WOODEN FLUSHED DOOR
3	GD1	150MM	2550MM	2560X2400	SOUVENIR SHO	GLAZED OPENABLE DOOR
4	D3	0	3500MM	3000X3500	GALLERY	SLIDING PANEL DOOR
5	G1	0	2300MM	2560X2400	SOUVENIR SHOP	FIXED GLAZING
6	G2	125MM	2900MM	2550X2775	GALLERY	FIXED GLAZING
7	W1	1000MM	2500MM	2935X1500	TICKET COUNTER	GLAZING WINDOW
8	W2	1000MM	2500MM	1200X1500	ADMIN	GLAZING WINDOW

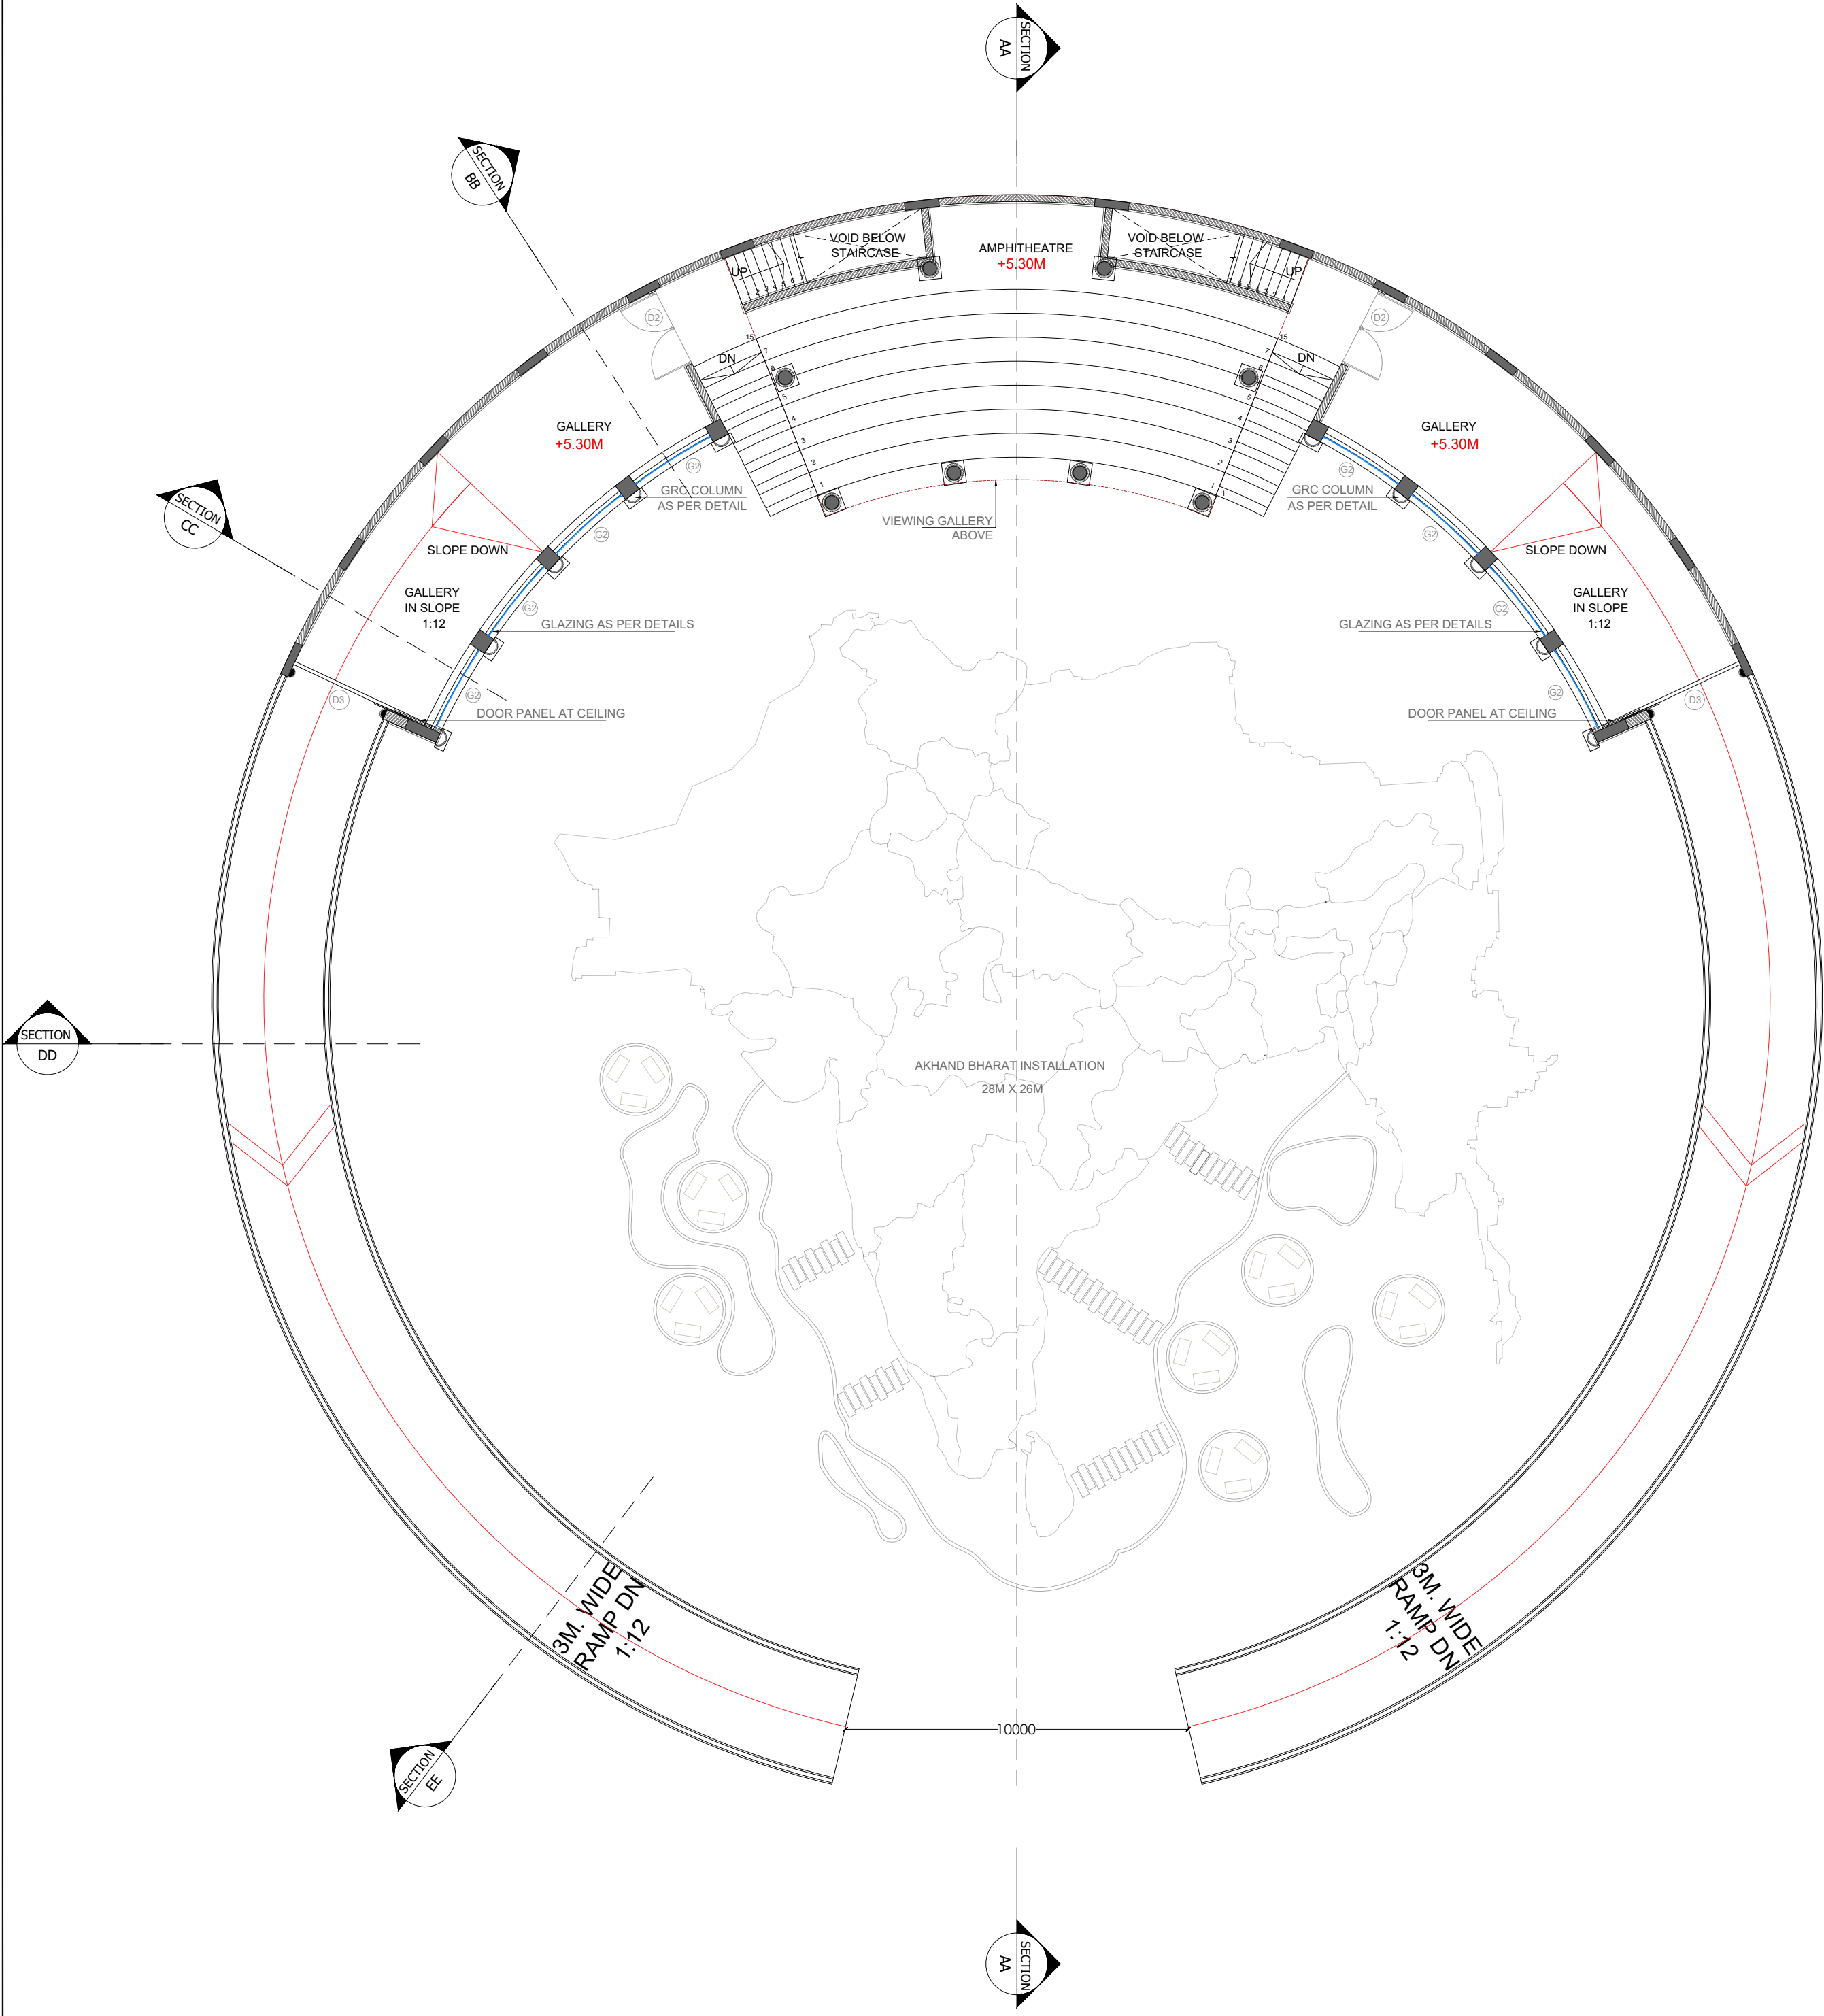

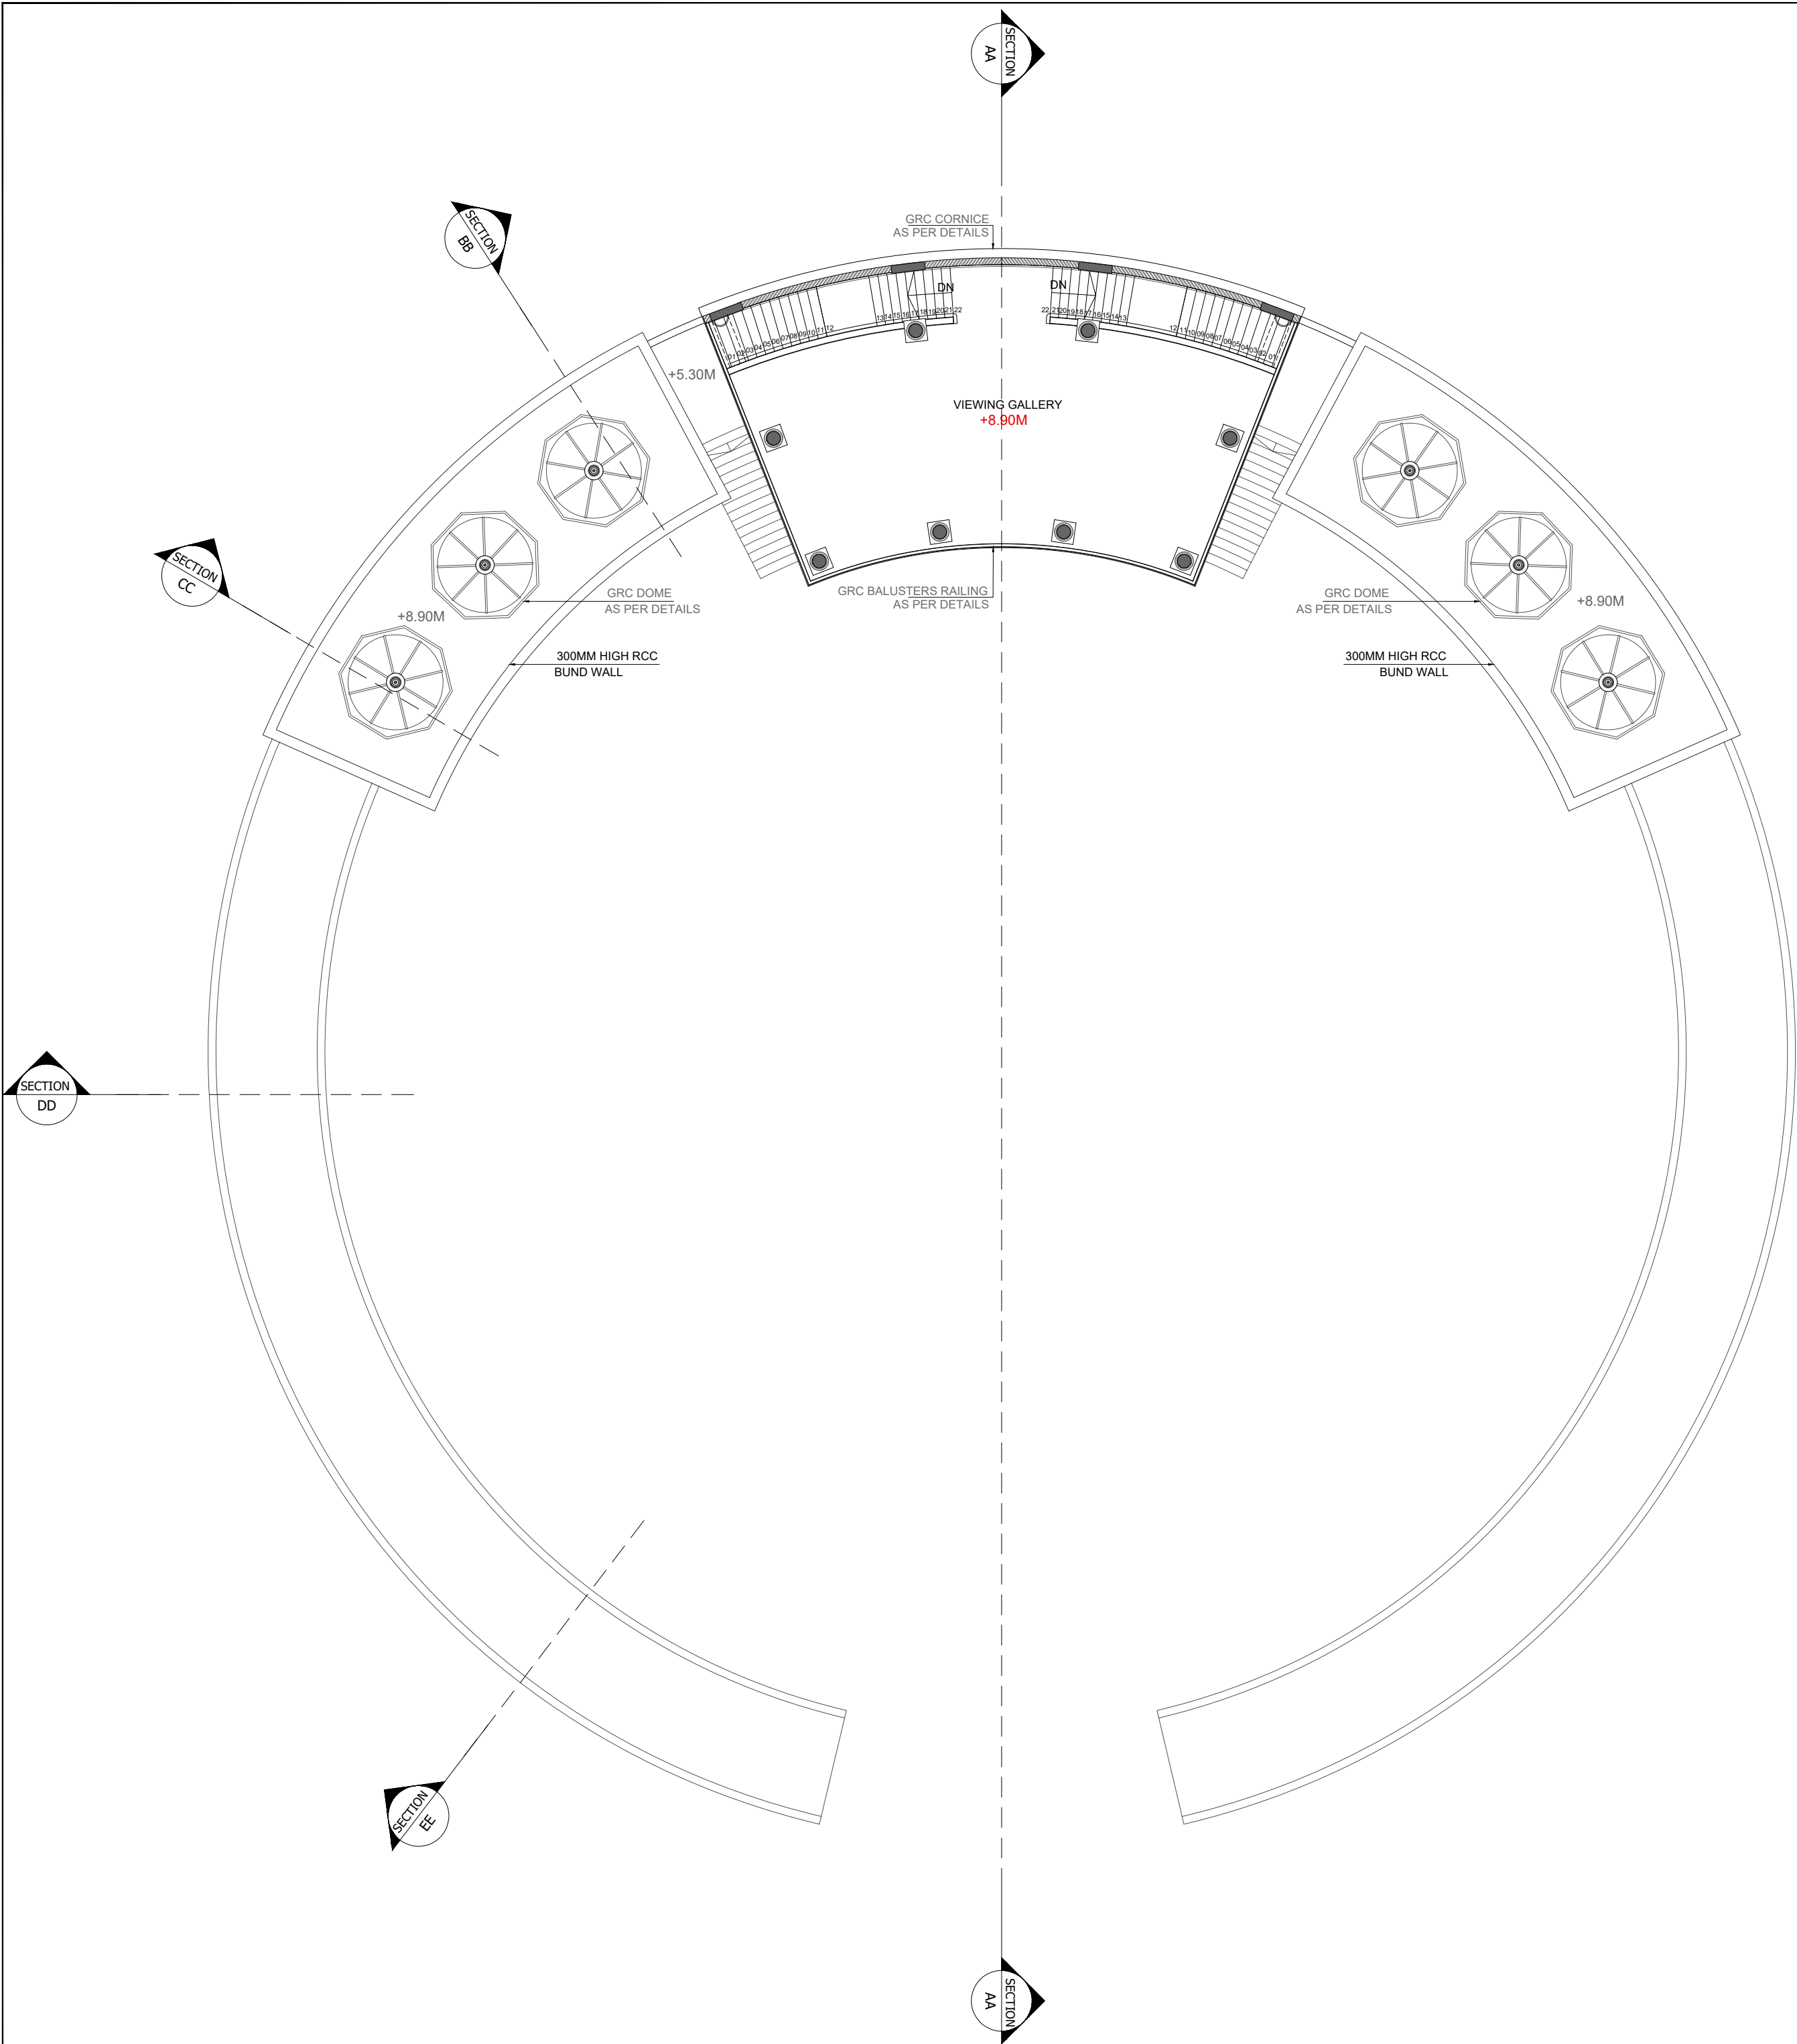

SR. NO.	DOOR/ WINDO W NO.	SILL	LUNTEL	SIZE	LOCATION	DISCRPTION
1	D1	300MM	2400MM	900X2100	STORE, KITCHEN, ADMIN, TICKET	WOODEN FLUSHED DOOR
2	D2	0	2400MM	2200X2400	GALLERY	WOODEN FLUSHED DOOR
3	GD1	150MM	2550MM	2560X2400	SOUVENIR SHO	GLAZED OPENABLE DOOR
4	D3	0	3500MM	3000X3500	GALLERY	SLIDING PANEL DOOR
5	G1	0	2300MM	2560X2400	SOUVENIR SHOP	FIXED GLAZING
6	G2	125MM	2900MM	2550X2775	GALLERY	FIXED GLAZING
7	W1	1000MM	2500MM	2935X1500	TICKET COUNTER	GLAZING WINDOW
8	W2	1000MM	2500MM	1200X1500	ADMIN	GLAZING WINDOW

APS-BV-A-203-R0

0.0.0

GENERAL NOTES:

ALL DIMENSIONS SHOWN ARE IN MILLIMETERS
ALL SURFACE LEVELS ARE SHOWN IN METERS
THIS DRAWING SHALL NOT BE SCALED.
WRITTEN DIMENSIONS SHALL BE FOLLOWED.

DISCREPANCIES BETWEEN SITE CONDITION AND
DATA SHOWN ON DRAWING SHALL BE
BROUGHT TO THE NOTICE OF THE ARCHITECT
PRIOR TO CONSTRUCTION WORKS.

DRAWING NOTES:

1. THE INFORMATION ON THIS DRAWING
SUPERCEDES INFORMATION IN OTHER DRAWINGS.
2. ALL THE EXISTING TREES NEED TO BE RETAIN AND
TRIMMED.

KEY PLAN :

REV NO.	REVISION DETAILS	DATE

REVISION NOTES

CONSULTANTS:

STRUCTURAL
CONSULTANT :

Associated Structural
Engineers LLP.
607, Opal Square Opp. Ralladevi Lake, Barve Rd. Wagale Estate,
Thane (w) - 400 604.
Phone: +91-22-25812084/85, 8876072223
Email: info@asc.org.in Website: www.asc.org.in

MEP
CONSULTANT :


M/s. Specialised Mep
Engineering Consultants.
Thane - West
Email : specialisedmepconsultants@gmail.com

SCALE: 1:150	DRAWN BY SHRADDHA	
PAPER A2	CHECKED BY KALYANI	
DATE 17-10-2024	DRAWING TYPE : TENDER DRAWING	
DRAWING NAME:	VIEWING GALLERY PLAN	
REVISION NUMBER:	R0	
PROJECT NAME:	BAHURATNA VASUNDHARA - GUJARAT UNIVERSITY	
PROJECT NUMBER:		
ARCHITECT:	APICES STUDIO PVT. LTD.	
CLIENT NAME:	GUJARAT UNIVERSITY	

PROJECT ARCHITECTS

 
APICES STUDIO PVT. LTD.
203,204,205,LODHA SUPREMUS,
ROAD NO.22,WAGALE ESTATE,
THANE WEST - 400604
TEL: +91 22 25870701/702/703/704




APS-BV-A-204-R0		0.0.0
GENERAL NOTES: ALL DIMENSIONS SHOWN ARE IN MILLIMETERS ALL SURFACE LEVELS ARE SHOWN IN METERS THIS DRAWING SHALL NOT BE SCALED. WRITTEN DIMENSIONS SHALL BE FOLLOWED.		
DISCREPANCIES BETWEEN SITE CONDITION AND DATA SHOWN ON DRAWING SHALL BE BROUGHT TO THE NOTICE OF THE ARCHITECT PRIOR TO CONSTRUCTION WORKS.		
DRAWING NOTES: 1. THE INFORMATION ON THIS DRAWING SUPERCEDES INFORMATION IN OTHER DRAWINGS. 2. ALL THE EXISTING TREES SHOULD BE RETAIN AND TRIMMED.		
KEY PLAN :		
REV NO.	REVISION DETAILS	DATE
REVISION NOTES		
CONSULTANTS:		
STRUCTURAL CONSULTANT :	 Associated Structural Engineers LLP. 607, Opal Square, Opp. Rajadevi Lake, Barve Rd. Wagale Estate, Thane (w.) - 400 604. Phone: +91-22-20812084/85, 8976072223 Email: info@asc.org.in Website: www.asc.org.in	
MEP CONSULTANT : M/s. Specialised Mep Engineering Consultants. Thane - West Email : specialisedmepconsultants@gmail.com		
SCALE: 1:150	DRAWN BY SHRADDHA	
PAPER A2	CHECKED BY KALYANI	
DATE 15-10-2024	DRAWING TYPE : TENDER DRAWING	
DRAWING NAME: ROOF PLAN		
REVISION NUMBER: R0		
PROJECT NAME: BAHURATNA VASUNDHARA - GUJARAT UNIVERSITY		
PROJECT NUMBER:		
ARCHITECT:	APICES STUDIO PVT. LTD.	
CLIENT NAME:	GUJARAT UNIVERSITY	
PROJECT ARCHITECTS		
 APICES studio pvt. ltd.		
APICES STUDIO PVT. LTD. 203,204,205,LODHA SUPREMU, ROAD NO.22,WAGALE ESTATE, THANE WEST - 400604 TEL: +91 22 25870701/702/703/704		

GENERAL NOTES:
ALL DIMENSIONS SHOWN ARE IN MILLIMETERS
ALL SURFACE LEVELS ARE SHOWN IN METERS
THIS DRAWING SHALL NOT BE SCALED.
WRITTEN DIMENSIONS SHALL BE FOLLOWED.

DISCREPANCIES BETWEEN SITE CONDITION AND
DATA SHOWN ON DRAWING SHALL BE
BROUGHT TO THE NOTICE OF THE ARCHITECT
PRIOR TO CONSTRUCTION WORKS.

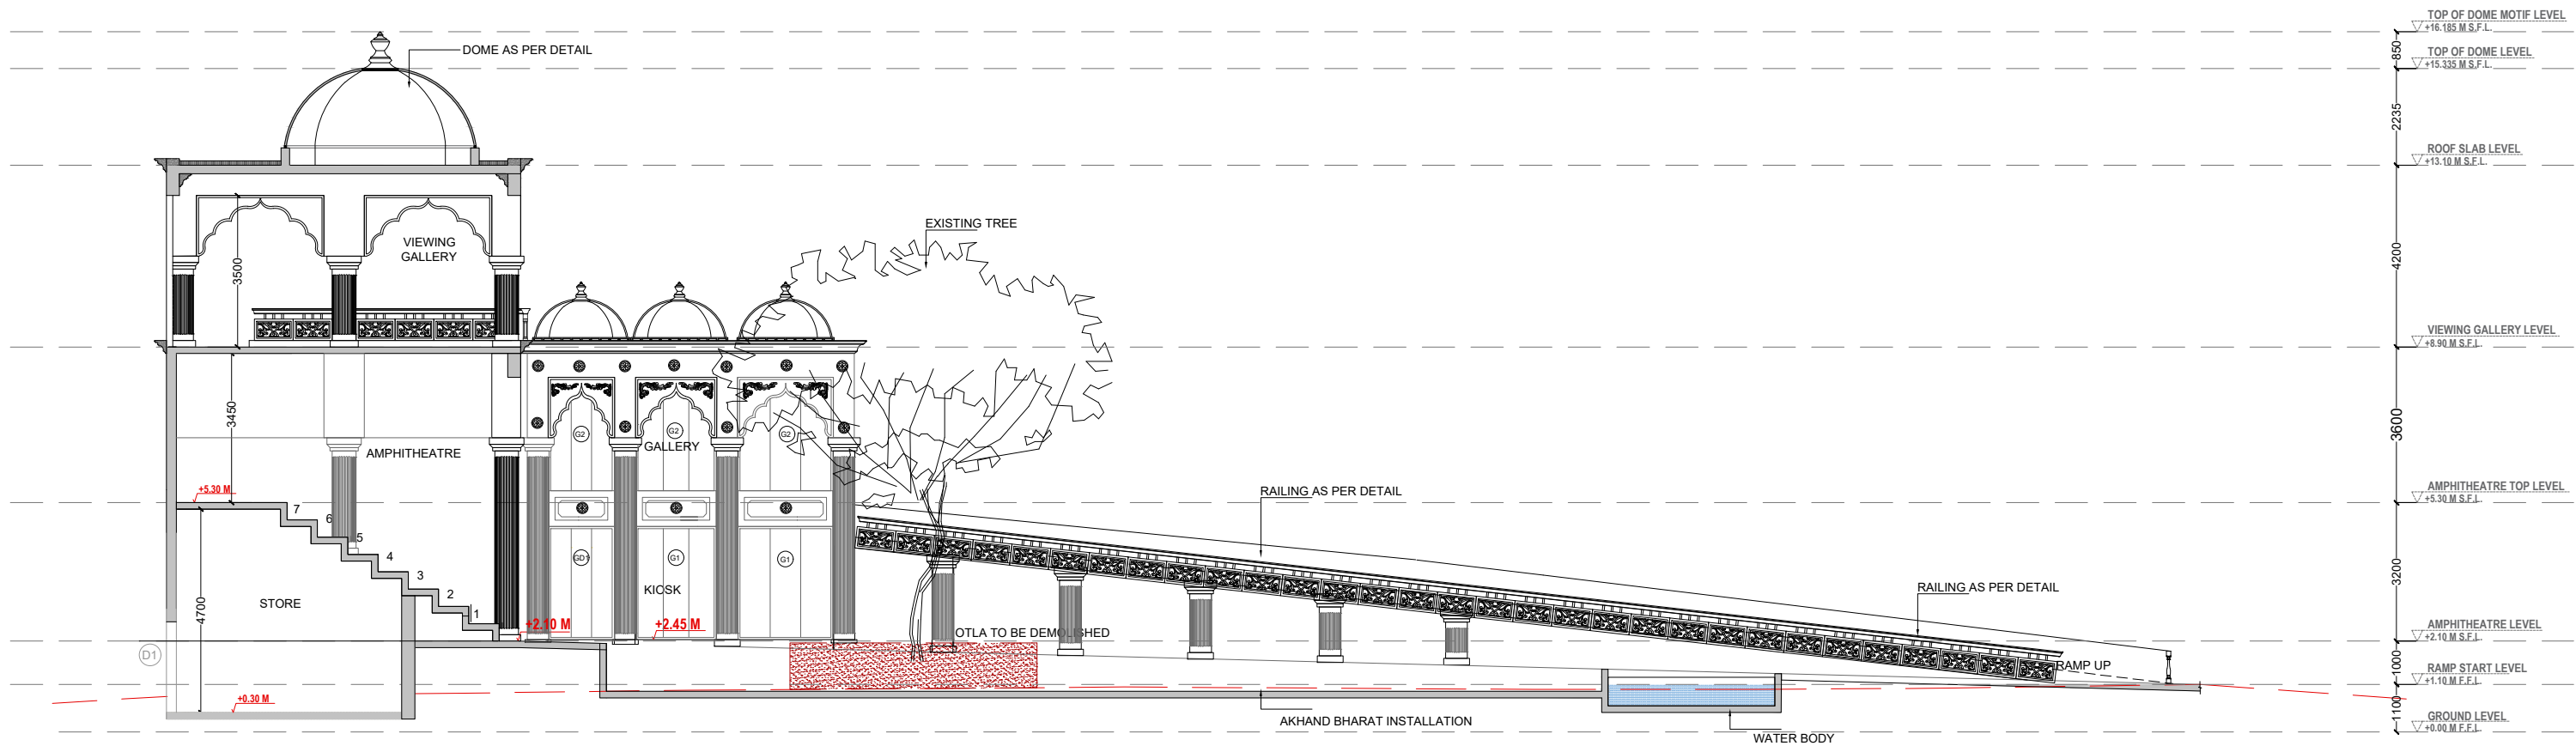

SECTION AA

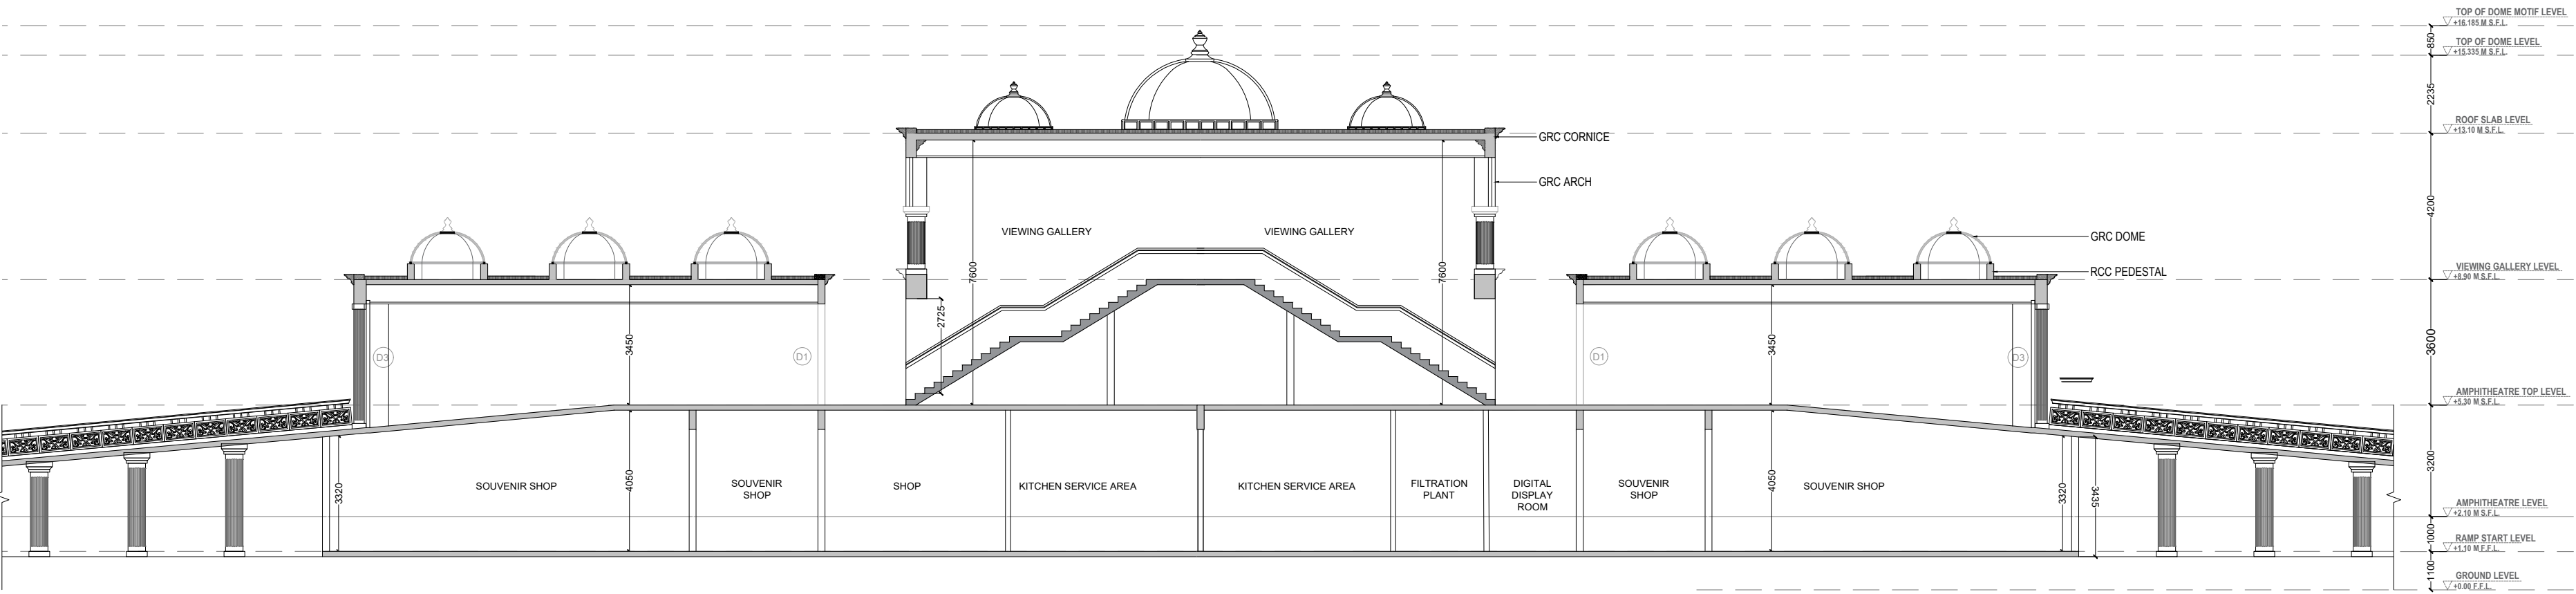

SECTION FF


REV NO.	REVISION DETAILS	DATE

REVISION NOTES

CONSULTANTS:

STRUCTURAL CONSULTANT :  Associated Structural Engineers LLP.
607, Opal Square Opp. Ralladevi Lake, Barve Rd. Wagale Estate, Thane (w) - 400 604.
Phone: +91 22 25872223 Email: info@asc.org.in Website: www.asc.org.in




 
MEP CONSULTANT :

SCALE: 1:150	DRAWN BY SAKSHI		
PAPER A2	CHECKED BY KALYANI		
DATE 17-10-2024	DRAWING TYPE : TENDER DRAWING		
DRAWING NAME:	SECTION		
REVISION NUMBER:	R0		
PROJECT NAME:	BAHURATNA VASUNDHARA - GUJARAT UNIVERSITY		
PROJECT NUMBER:			
ARCHITECT:	APICES STUDIO PVT. LTD.		
CLIENT NAME:	GUJARAT UNIVERSITY		

PROJECT ARCHITECTS



APICES STUDIO PVT. LTD.
203,204,205,LODHA SUPREMUS,
ROAD NO.22,WAGALE ESTATE,
THANE WEST - 400604
TEL: +91 22 25870701/702/703/704

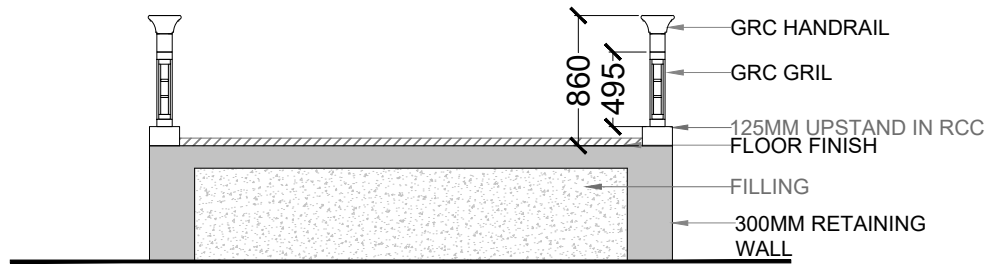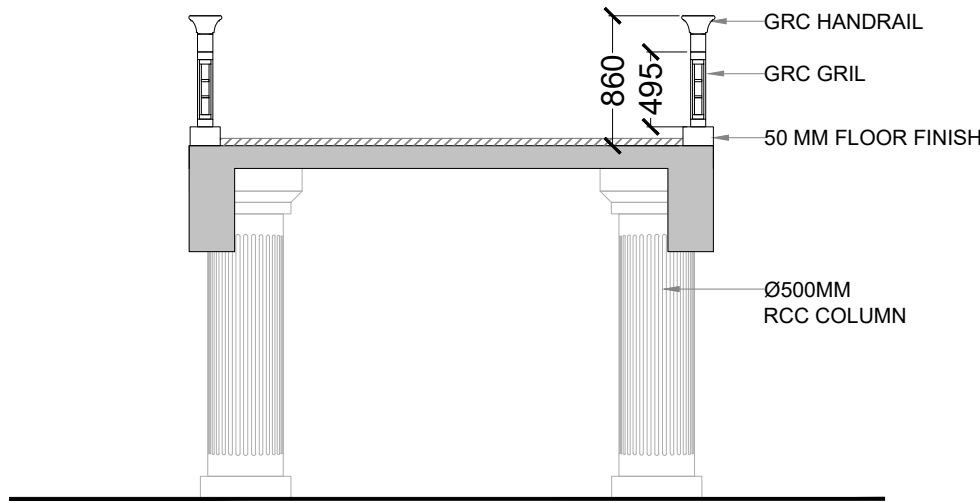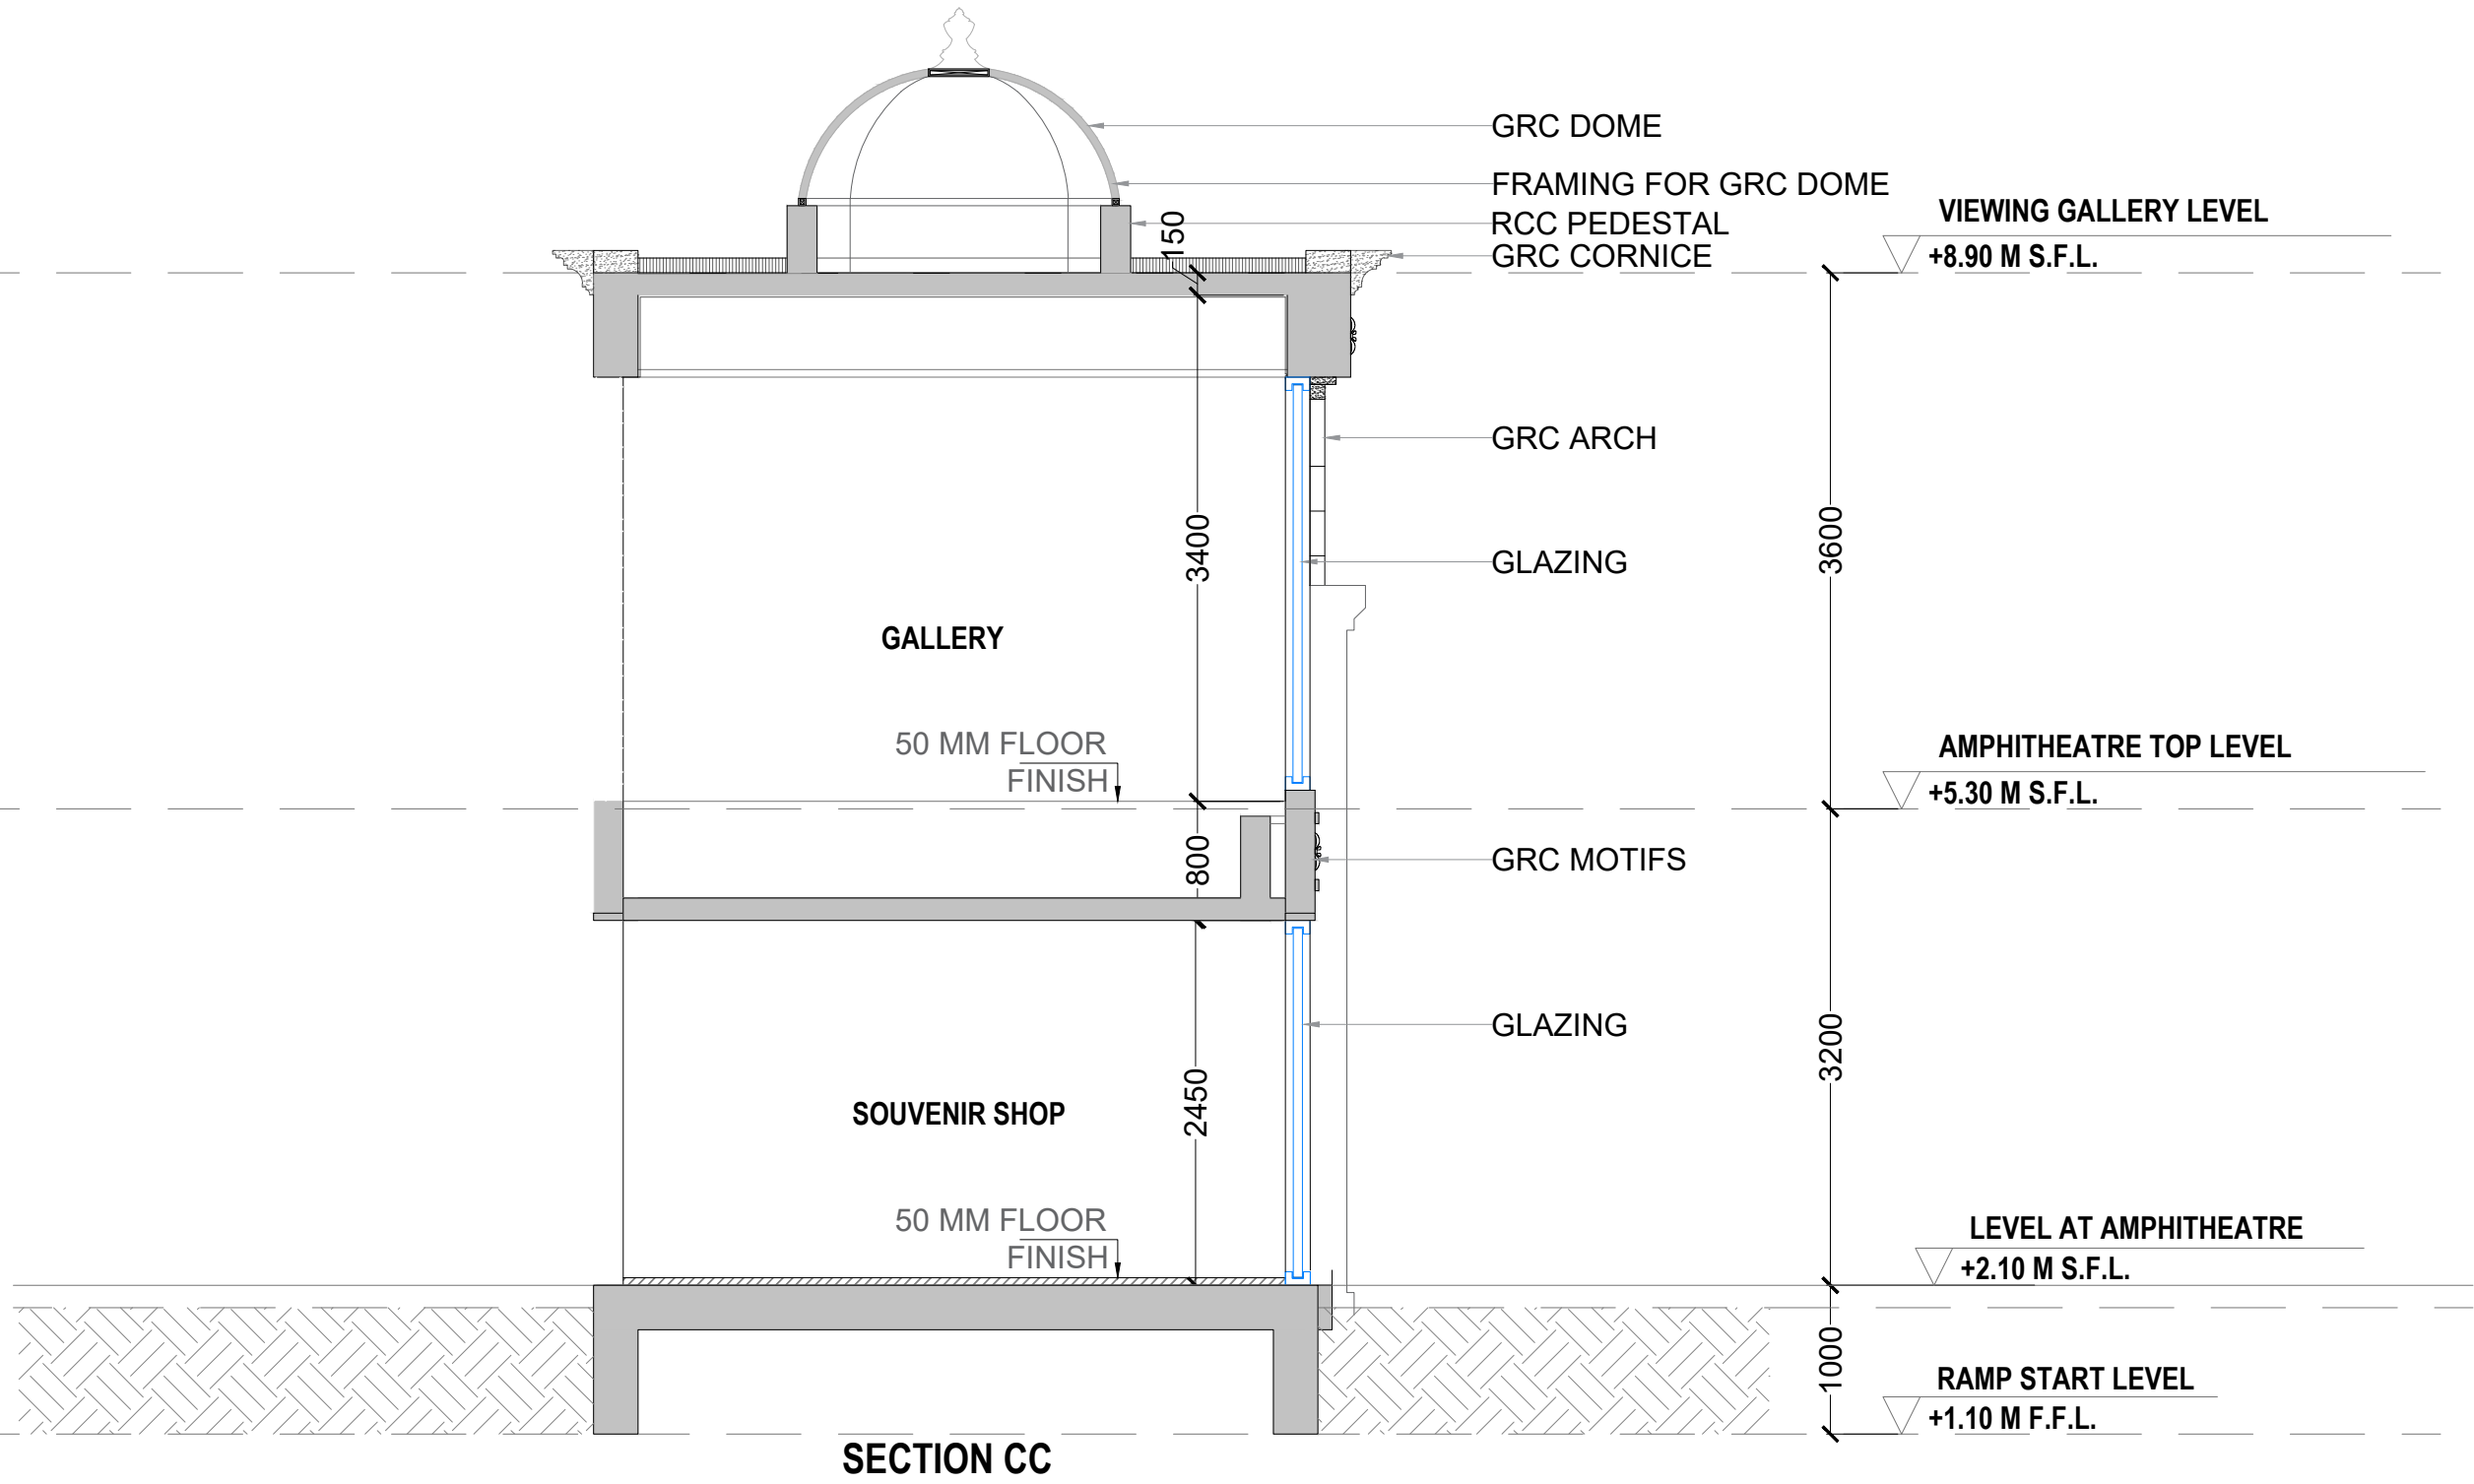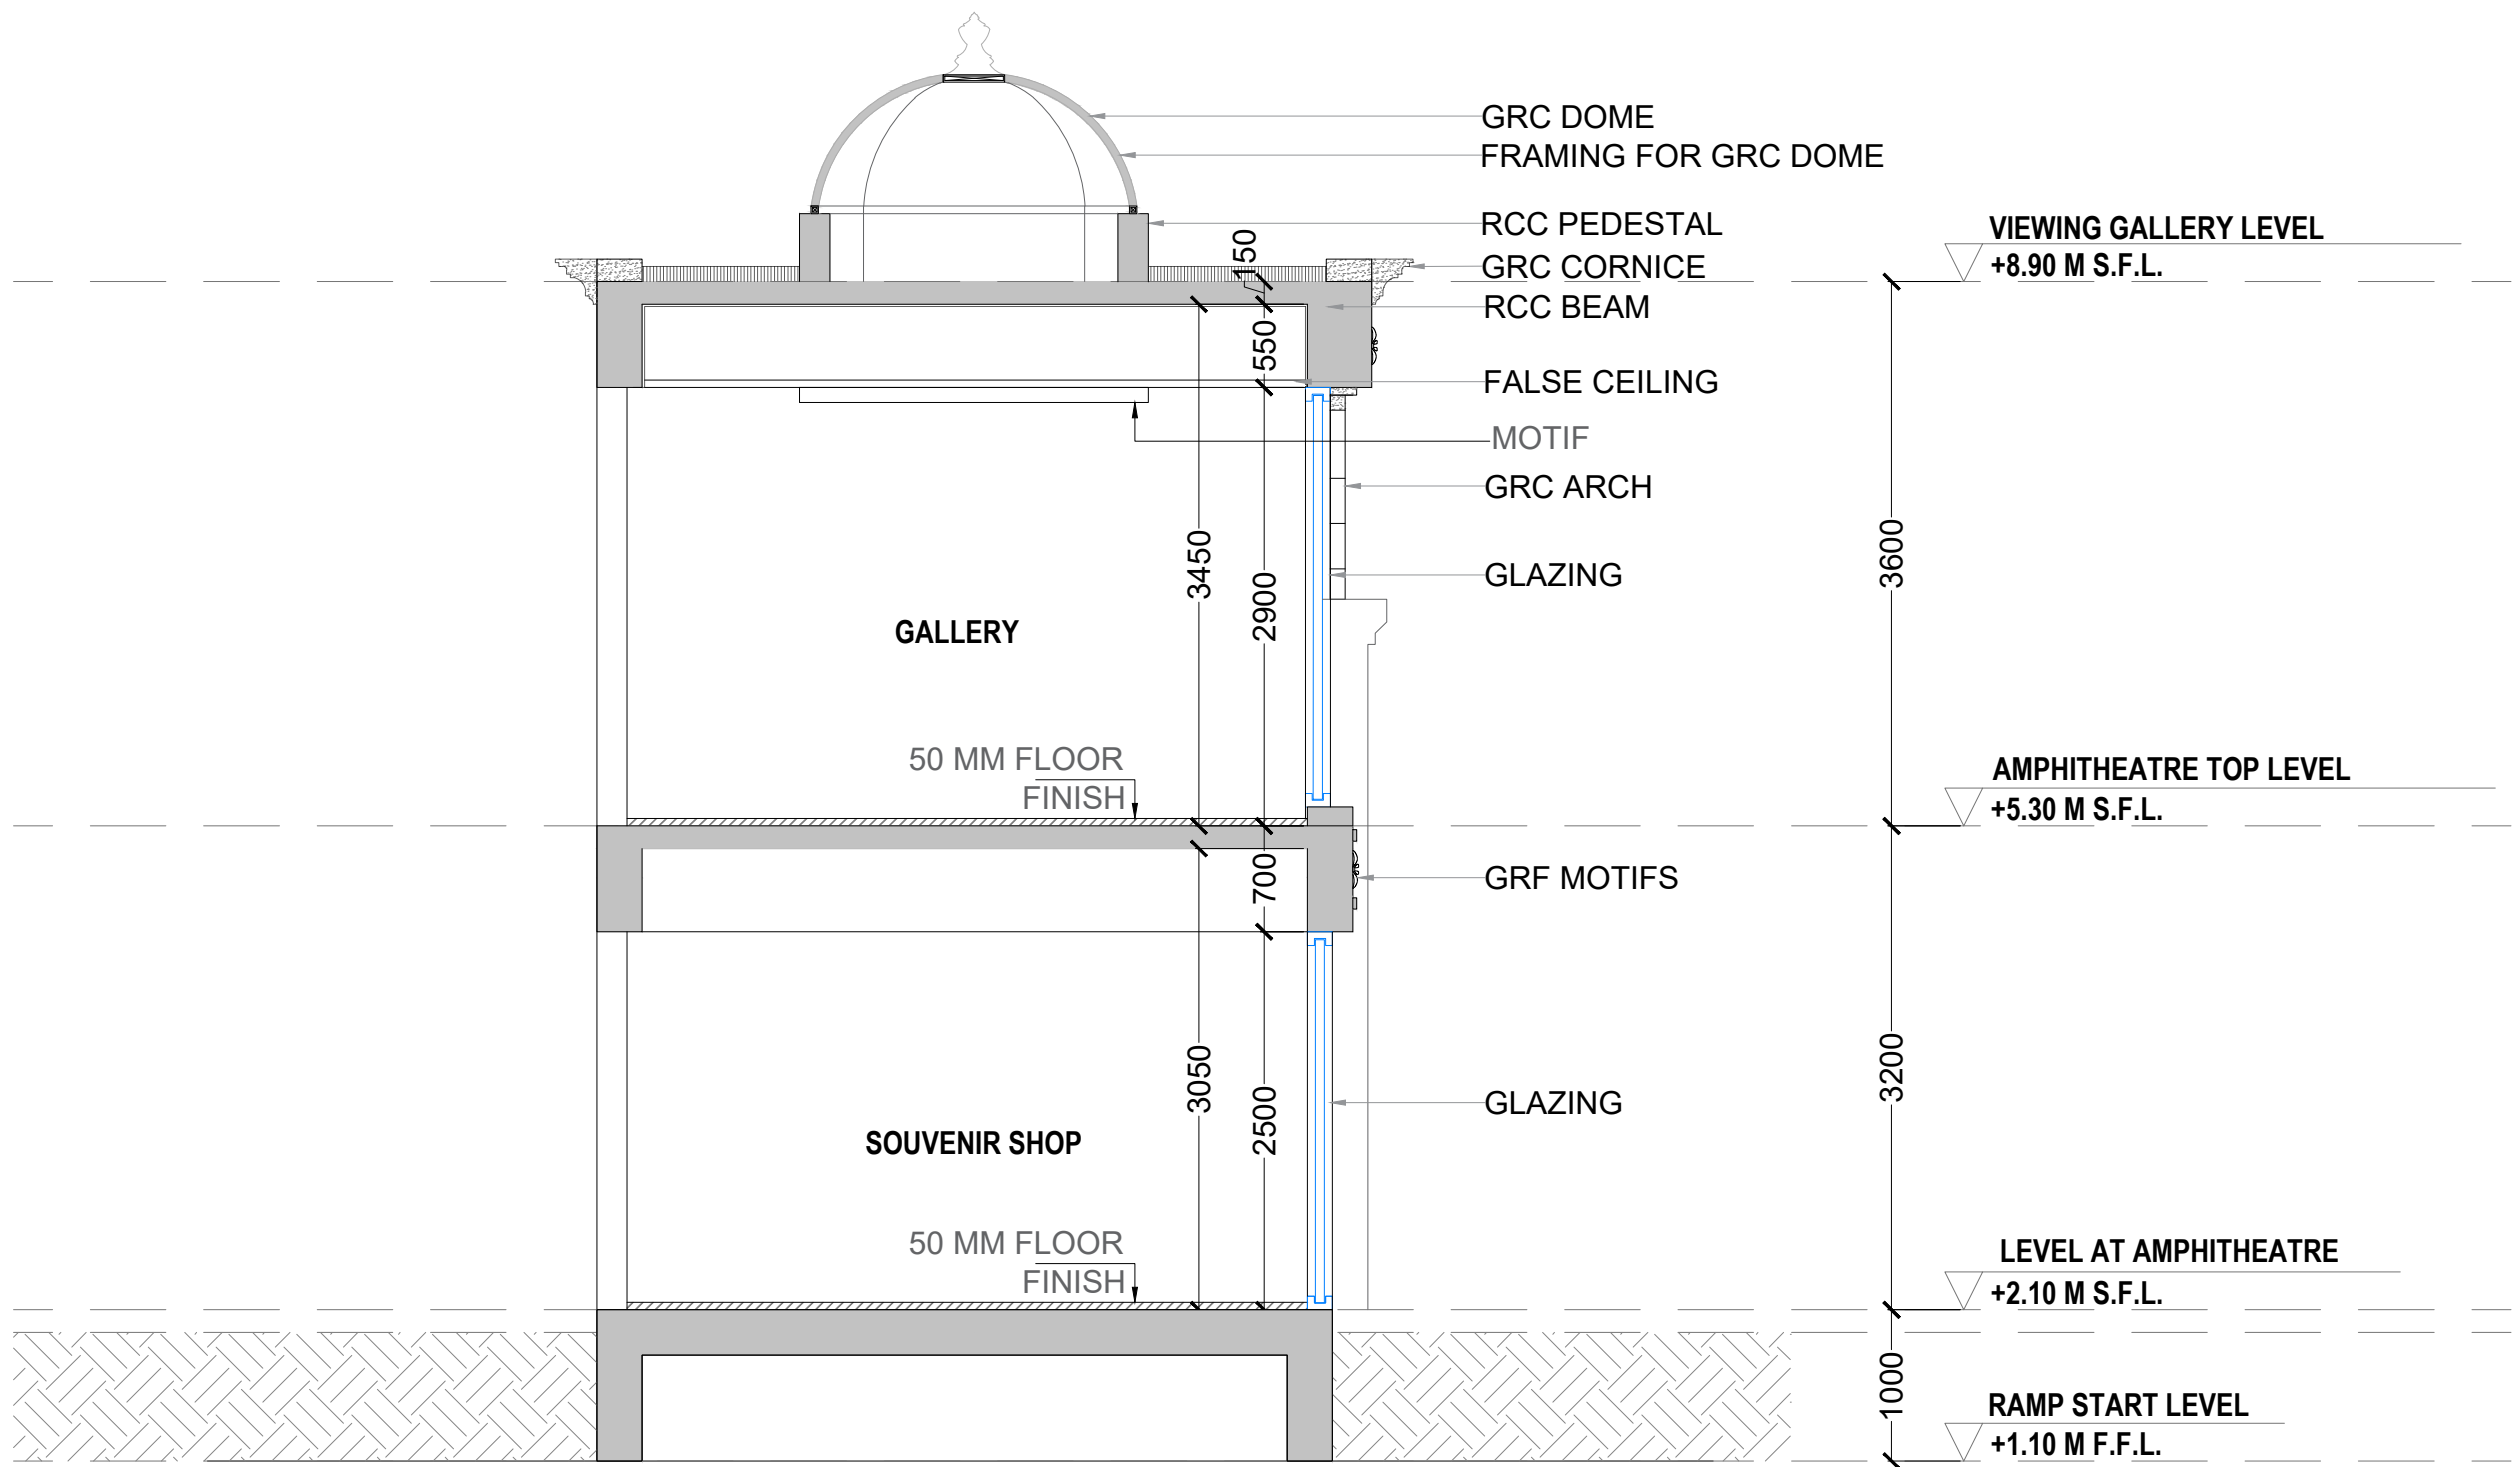

GENERAL NOTES:
ALL DIMENSIONS SHOWN ARE IN MILLIMETERS
ALL SURFACE LEVELS ARE SHOWN IN METERS
THIS DRAWING SHALL NOT BE SCALED.
WRITTEN DIMENSIONS SHALL BE FOLLOWED.

DISCREPANCIES BETWEEN SITE CONDITION AND DATA SHOWN ON DRAWING SHALL BE BROUGHT TO THE NOTICE OF THE ARCHITECT PRIOR TO CONSTRUCTION WORKS.

DRAWING NOTES:
1. THE INFORMATION ON THIS DRAWING SUPERCEDES INFORMATION IN OTHER DRAWINGS.
2. ALL THE EXISTING TREES NEED TO BE RETAIN AND TRIMMED.

KEY PLAN :


REV NO.	REVISION DETAILS	DATE
---------	------------------	------

REVISION NOTES

CONSULTANTS:

STRUCTURAL CONSULTANT :  Associated Structural Engineers LLP.
Thane (w) - 400 604.
607, Opal Square Opp. Ralladevi Lake, Barve Rd. Wagale Estate,
Phone: +91-22-25812084/85, 8876072223
Email: info@asc.org.in Website: www.asc.org.in

 
MEP CONSULTANT :
M/s. Specialised Mep Engineering Consultants.
Thane - West
Email : specialisedmepconsultants@gmail.com

SCALE: 1:100	DRAWN BY SAKSHI		
PAPER A2	CHECKED BY KALYANI		
DATE 17-10-2024	DRAWING TYPE : TENDER DRAWING		
DRAWING NAME:	SECTIONS		
REVISION NUMBER:	R0		
PROJECT NAME:	BAHURATNA VASUNDHARA - GUJARAT UNIVERSITY		
PROJECT NUMBER:			
ARCHITECT:	APICES STUDIO PVT. LTD.		
CLIENT NAME:	GUJARAT UNIVERSITY		


PROJECT ARCHITECTS



APICES STUDIO PVT. LTD.
203,204,205,LODHA SUPREMUS,
ROAD NO.22,WAGALE ESTATE,
THANE WEST - 400604
TEL: +91 22 25870701/702/703/704

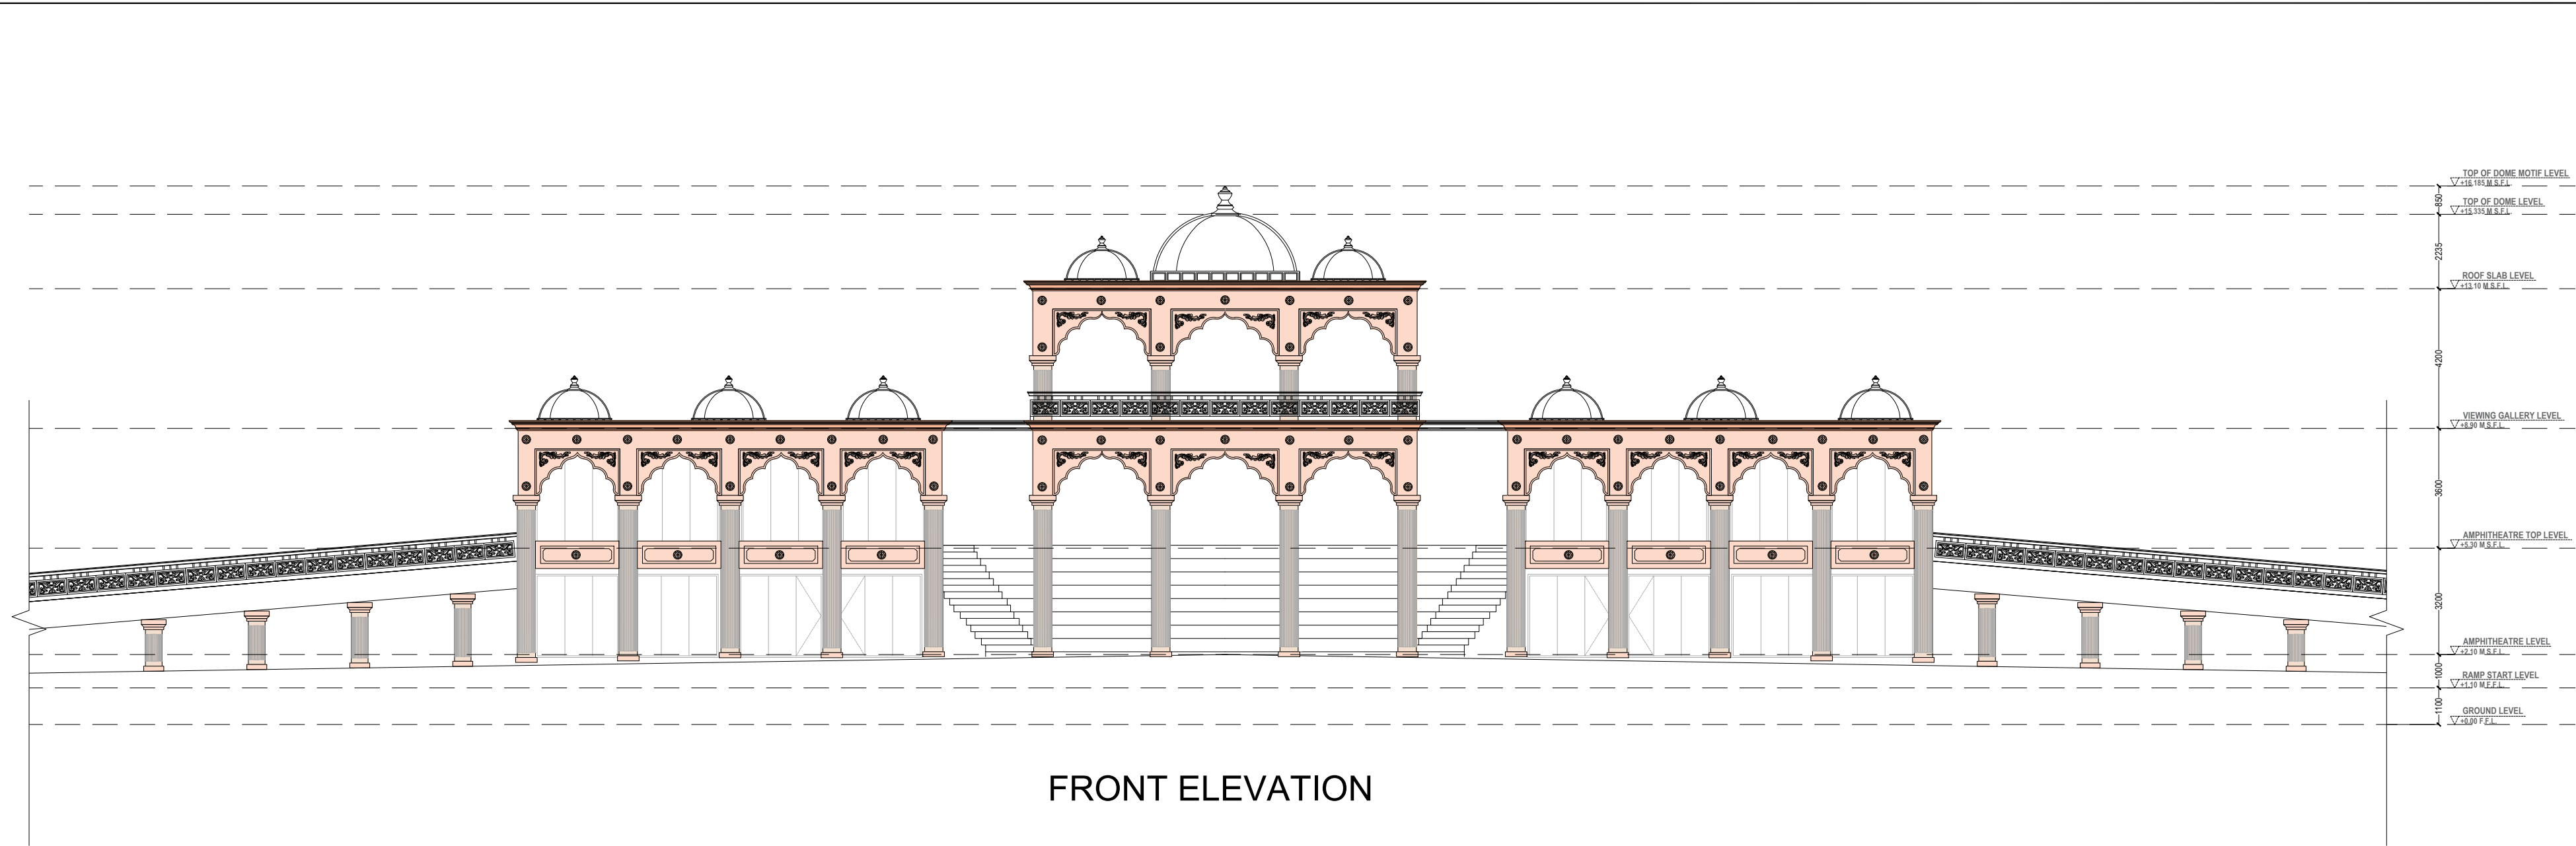

FRONT ELEVATION

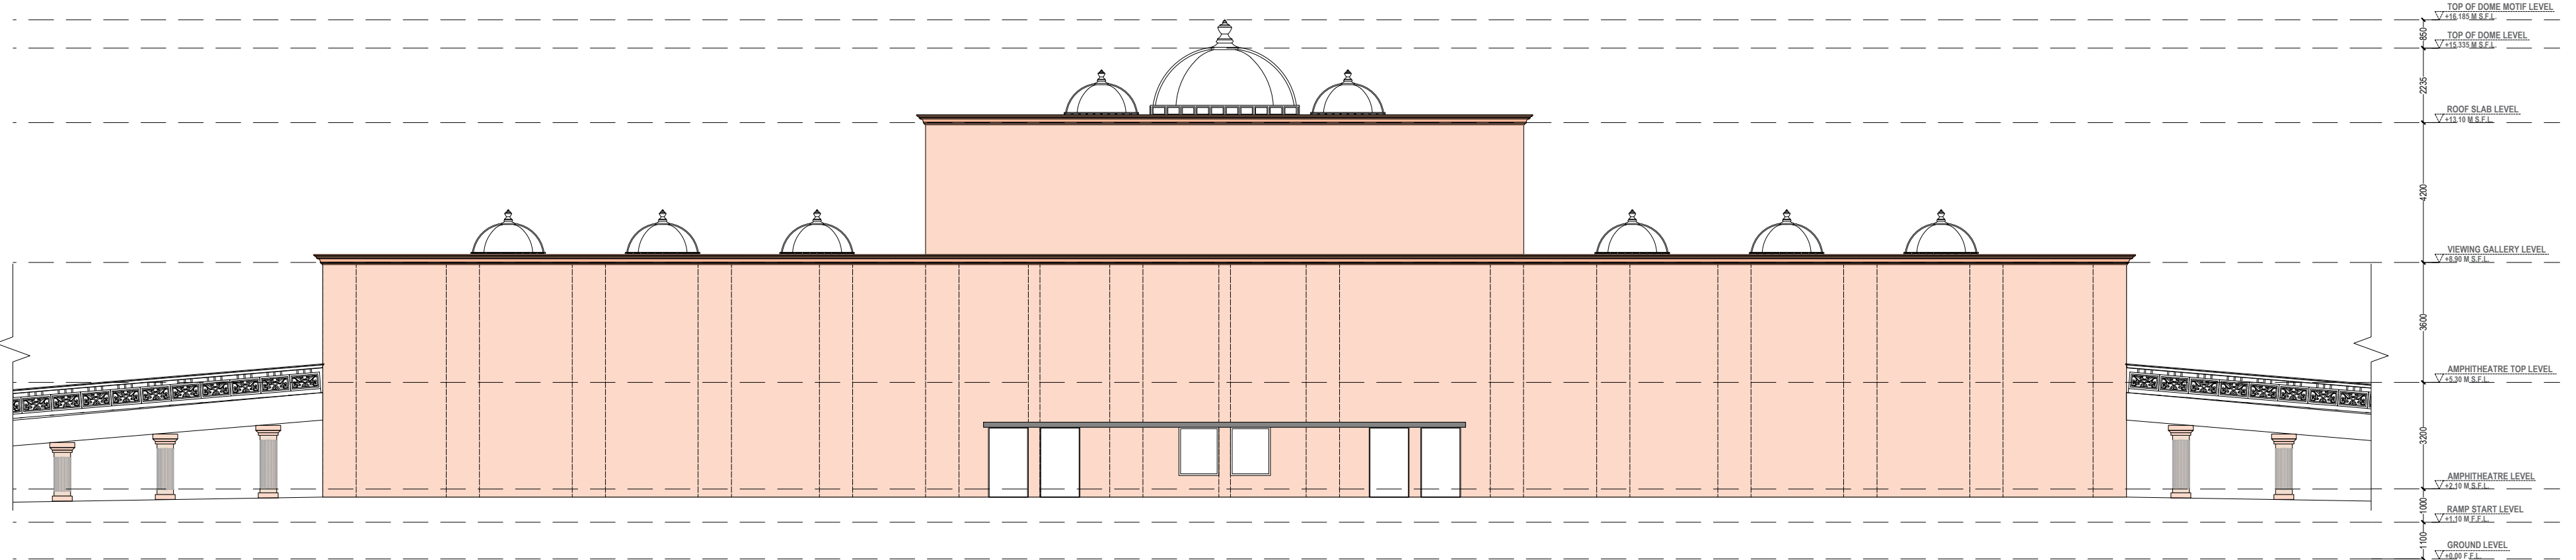

REAR ELEVATION

APS-BV-A-402-R0

0.0.0

GENERAL NOTES:
ALL DIMENSIONS SHOWN ARE IN MILLIMETERS
ALL SURFACE LEVELS ARE SHOWN IN METERS
THIS DRAWING SHALL NOT BE SCALED.
WRITTEN DIMENSIONS SHALL BE FOLLOWED.

DISCREPANCIES BETWEEN SITE CONDITION AND DATA SHOWN ON DRAWING SHALL BE BROUGHT TO THE NOTICE OF THE ARCHITECT PRIOR TO CONSTRUCTION WORKS.

DRAWING NOTES:
1. THE INFORMATION ON THIS DRAWING SUPERCEDES INFORMATION IN OTHER DRAWINGS.
2. ALL THE EXISTING TREES NEED TO BE RETAIN AND TRIMMED.

KEY PLAN :

REV NO.	REVISION DETAILS	DATE

REVISION NOTES

CONSULTANTS:

 
STRUCTURAL CONSULTANT :



Associated Structural Engineers LLP.
007, Opal Square Opp. Ralladevi Lake, Barve Rd. Wagale Estate, Thane (w) - 400 604.
Phone: +91-22-20812084/85, 8676072223
Email: info@asc.org.in Website: www.asc.org.in

MEP CONSULTANT :

M/s. Specialised Mep Engineering Consultants.
Thane - West
Email : specialisedmepconsultants@gmail.com

SCALE: 1:150	DRAWN BY MEGHAL	
PAPER A2	CHECKED BY KALYANI	
DATE 17-10-2024	DRAWING TYPE: TENDER DRAWING	
DRAWING NAME:	ELEVATIONS	
REVISION NUMBER:	R0	
PROJECT NAME:	BAHURATNA VASUNDHARA - GUJARAT UNIVERSITY	
PROJECT NUMBER:		
ARCHITECT:	APICES STUDIO PVT. LTD.	
CLIENT NAME:	GUJARAT UNIVERSITY	

PROJECT ARCHITECTS



APICES
studio pvt. ltd.

APICES STUDIO PVT. LTD.
203,204,205,LODHA SUPREMUS,
ROAD NO.22,WAGALE ESTATE,
THANE WEST - 400604
TEL: +91 22 25870701/702/703/704

GENERAL NOTES:
ALL DIMENSIONS SHOWN ARE IN MILLIMETERS
ALL SURFACE LEVELS ARE SHOWN IN METERS
THIS DRAWING SHALL NOT BE SCALED.
WRITTEN DIMENSIONS SHALL BE FOLLOWED.

DISCREPANCIES BETWEEN SITE CONDITION AND DATA SHOWN ON DRAWING SHALL BE BROUGHT TO THE NOTICE OF THE ARCHITECT PRIOR TO CONSTRUCTION WORKS.

DRAWING NOTES:
1. THE INFORMATION ON THIS DRAWING SUPERCEDES INFORMATION IN OTHER DRAWINGS.
2. ALL THE EXISTING TREES NEED TO BE RETAIN AND TRIMMED.

KEY PLAN :

REV NO.	REVISION DETAILS	DATE
---------	------------------	------

REVISION NOTES

CONSULTANTS:

STRUCTURAL CONSULTANT :  Associated Structural Engineers LLP.
007, Opal Square Opp. Ralladevi Lake, Barve Rd. Wagale Estate, Thane (w) - 400 604.
Phone: +91-22-20812084/85, 8676072223
Email: info@asc.org.in Website: www.asc.org.in


MEP CONSULTANT :
M/s. Specialised Mep Engineering Consultants.
Thane - West
Email : specialisedmepconsultants@gmail.com

SCALE: 1:150	DRAWN BY MEGHAL	
PAPER A2	CHECKED BY KALYANI	
DATE 17-10-2024	DRAWING TYPE : TENDER DRAWING	
DRAWING NAME:	ELEVATION	
REVISION NUMBER:	R0	
PROJECT NAME:	BAHURATNA VASUNDHARA - GUJARAT UNIVERSITY	
PROJECT NUMBER:		
ARCHITECT:	APICES STUDIO PVT. LTD.	
CLIENT NAME:	GUJARAT UNIVERSITY	


PROJECT ARCHITECTS




APICES STUDIO PVT. LTD.
203,204,205,LODHA SUPREMUS,
ROAD NO.22,WAGALE ESTATE,
THANE WEST - 400604
TEL: +91 22 25870701/702/703/704

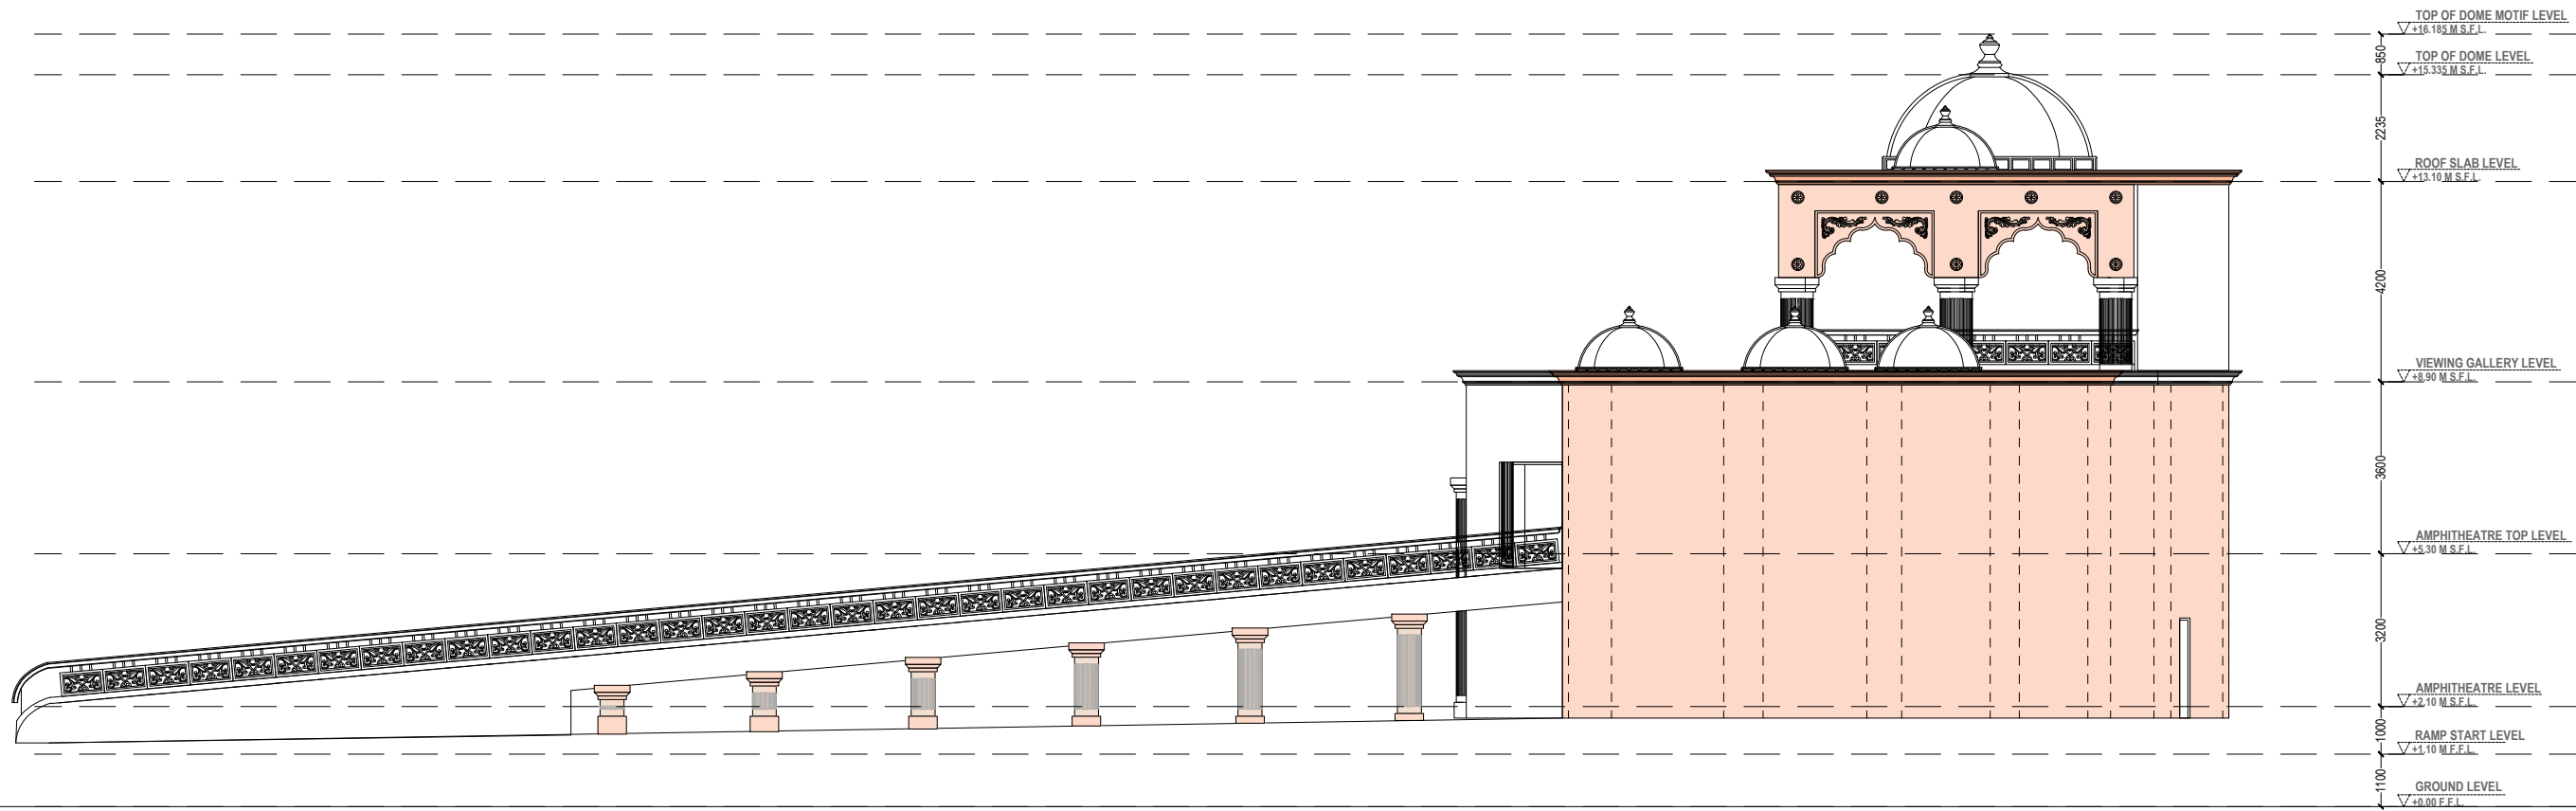


EAST ELEVATION

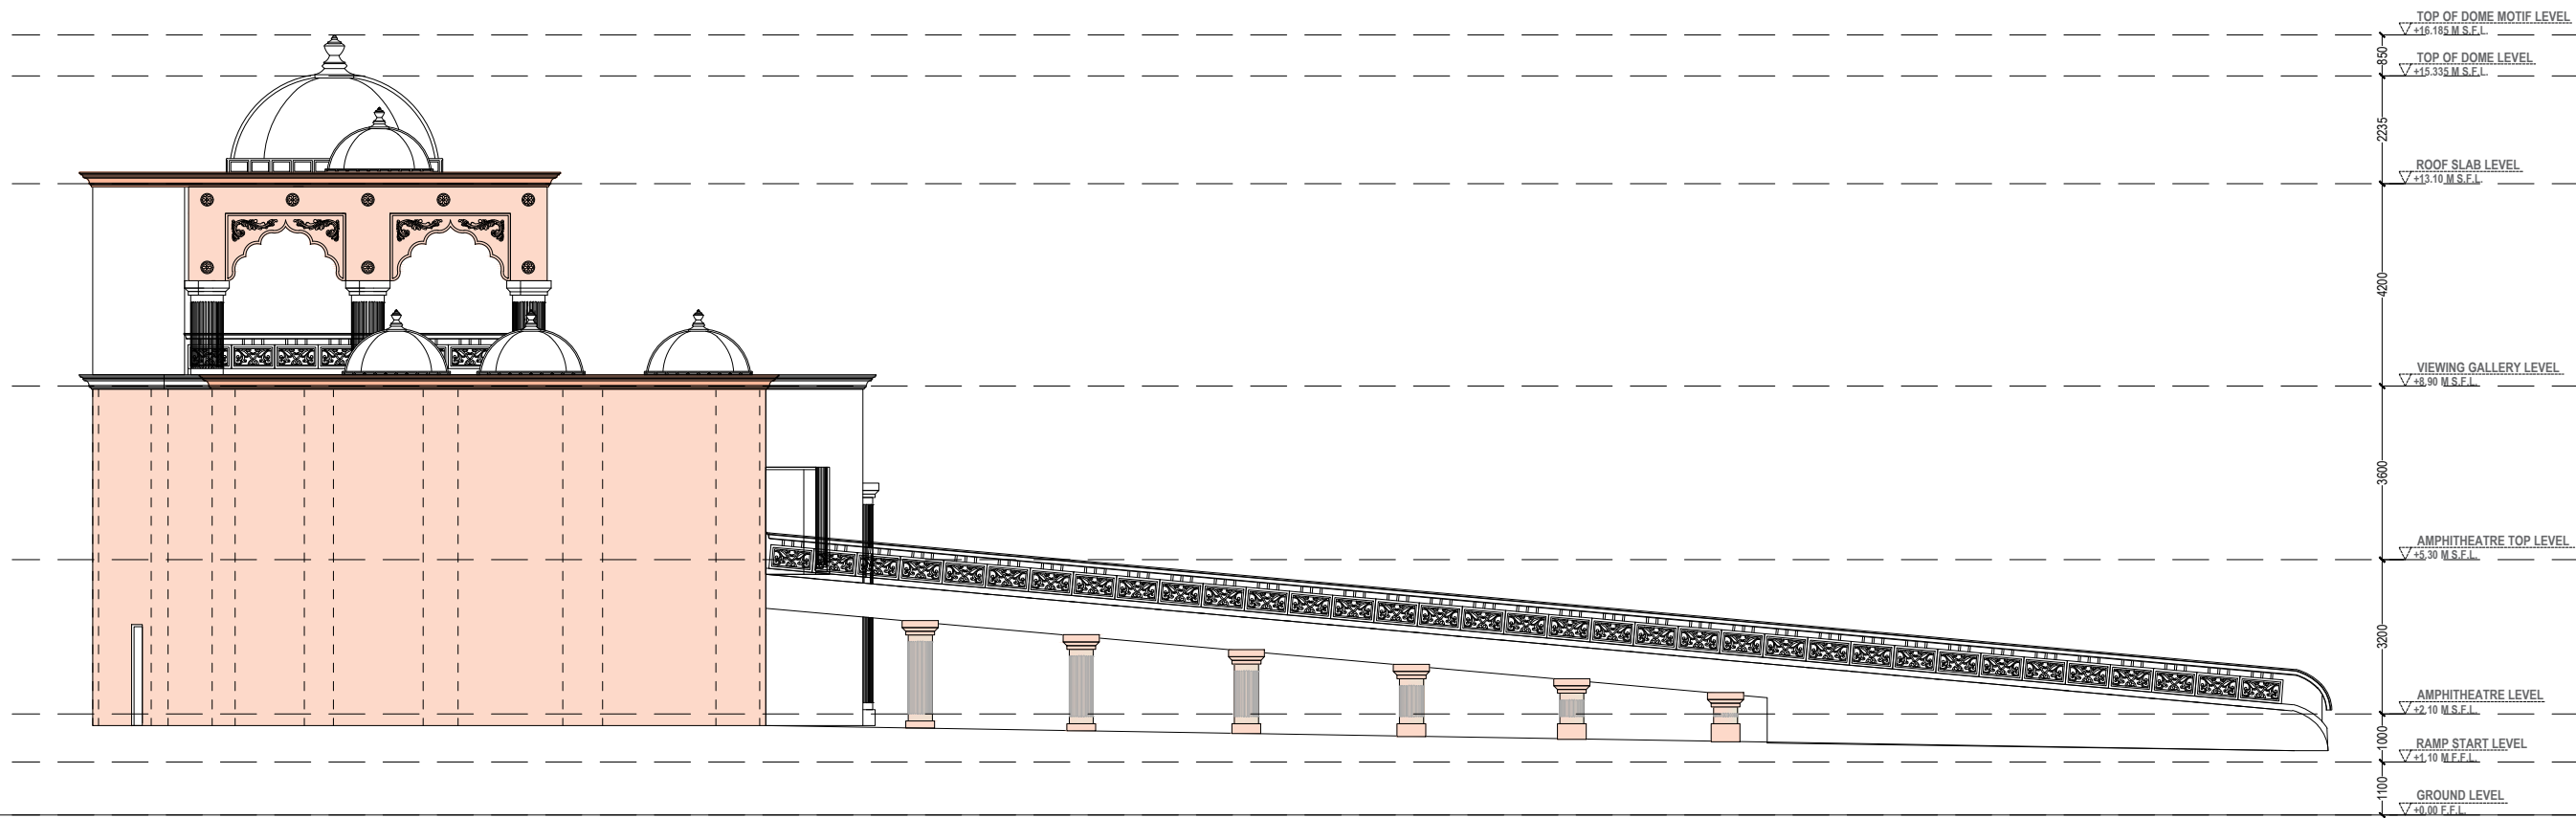


WEST ELEVATION

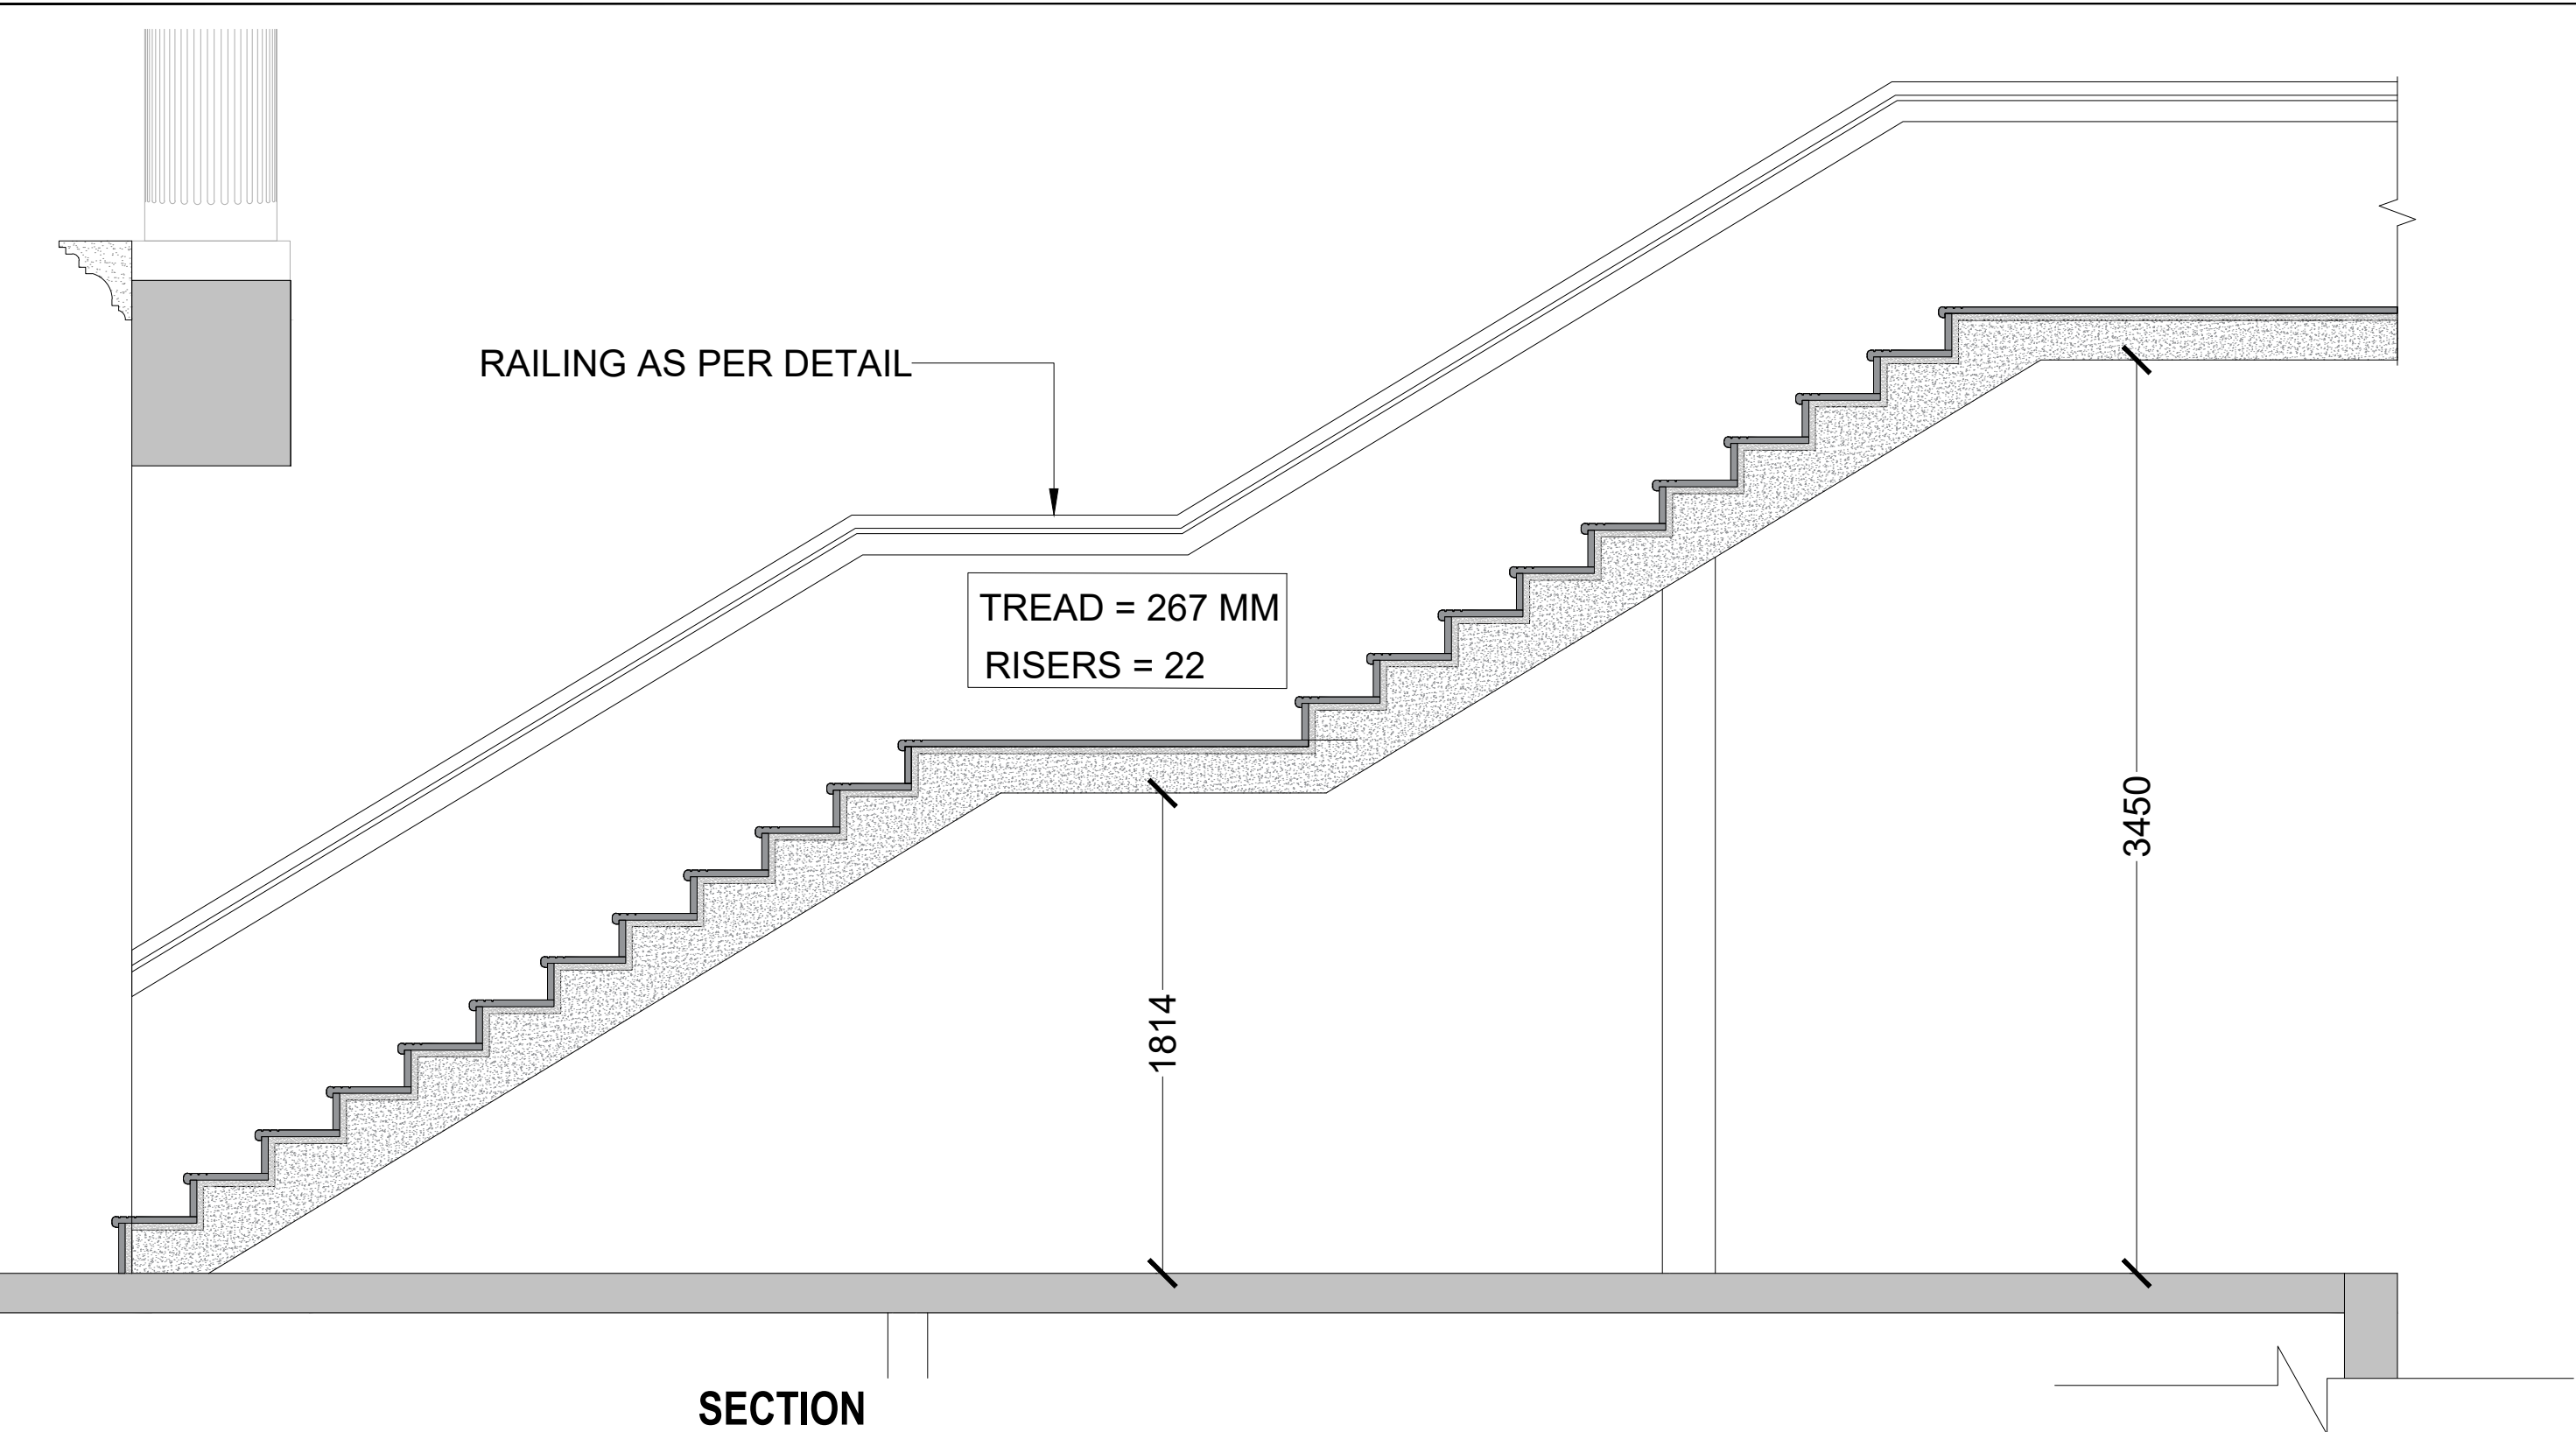


SECTION

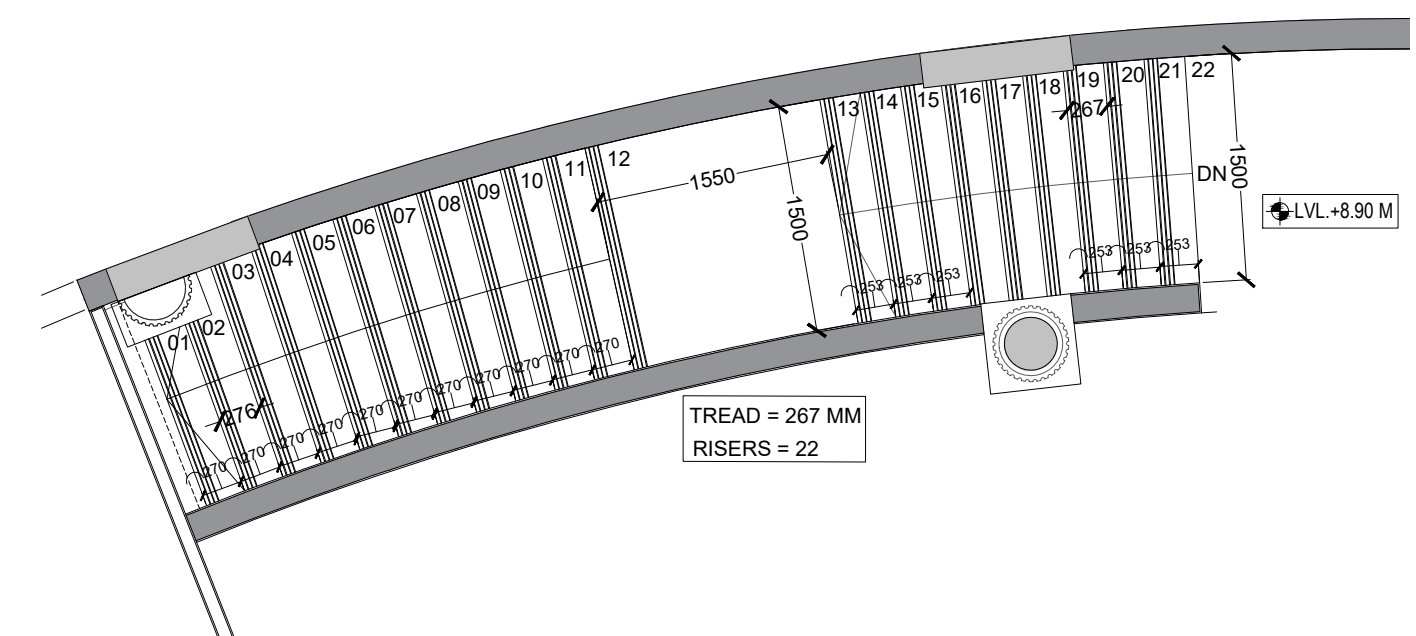


PLAN

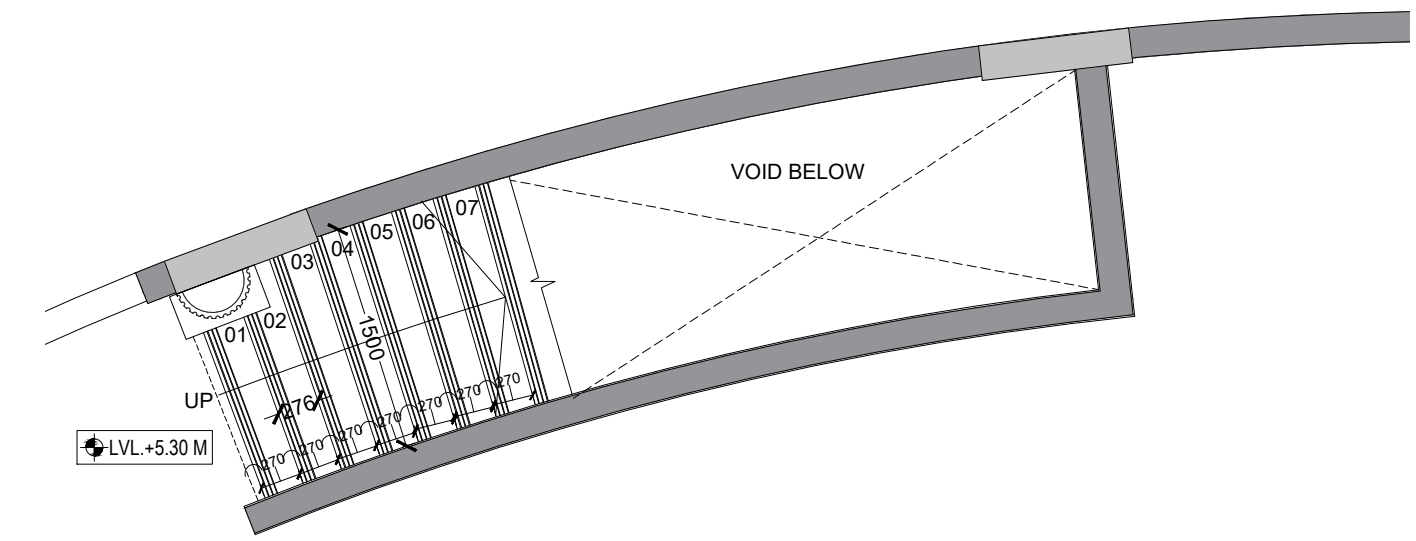


PLAN

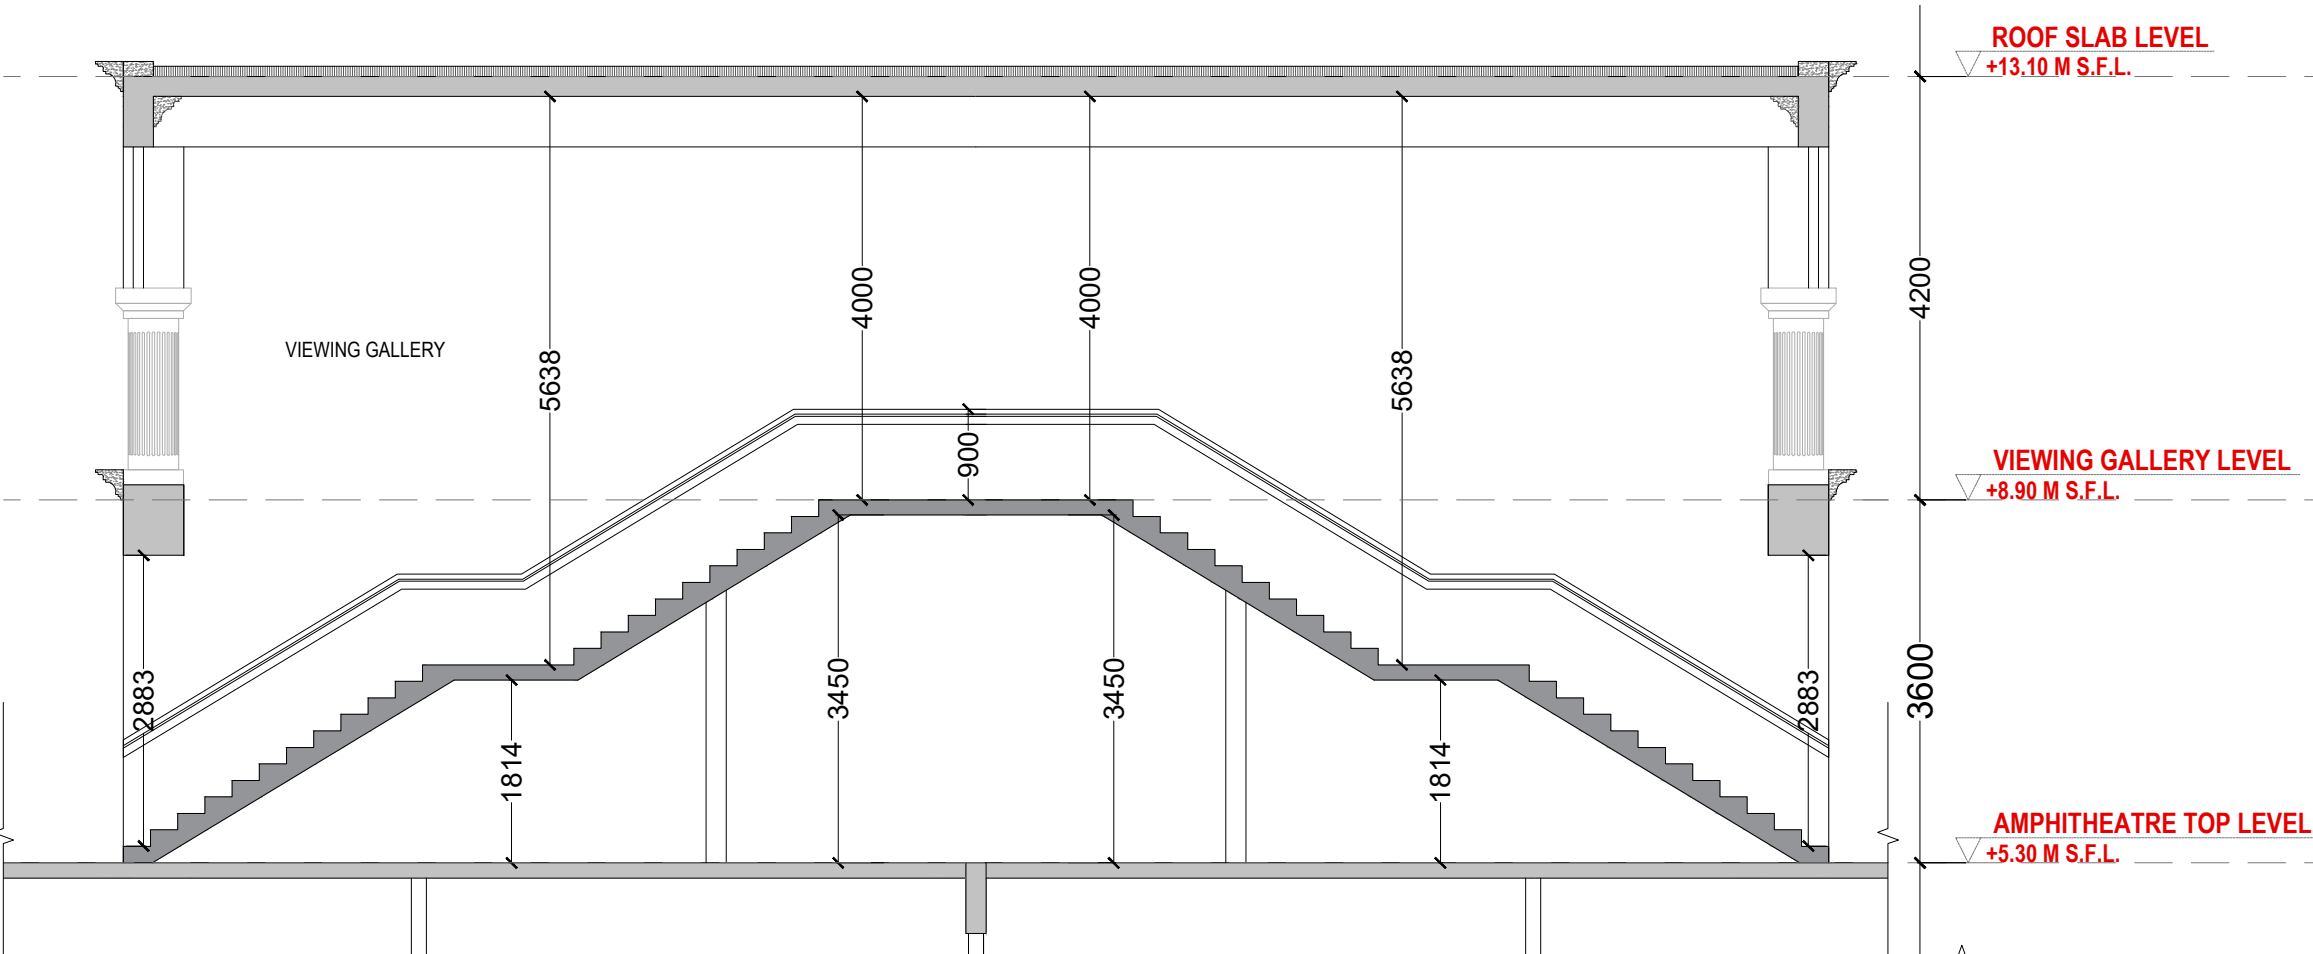


SECTION






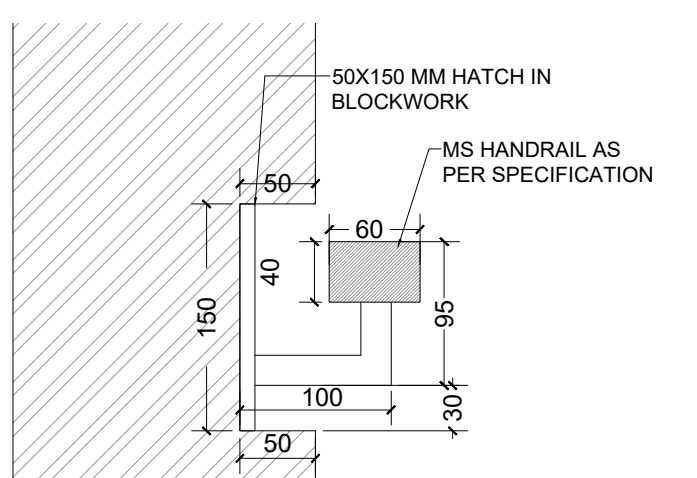


RAILING DETAIL

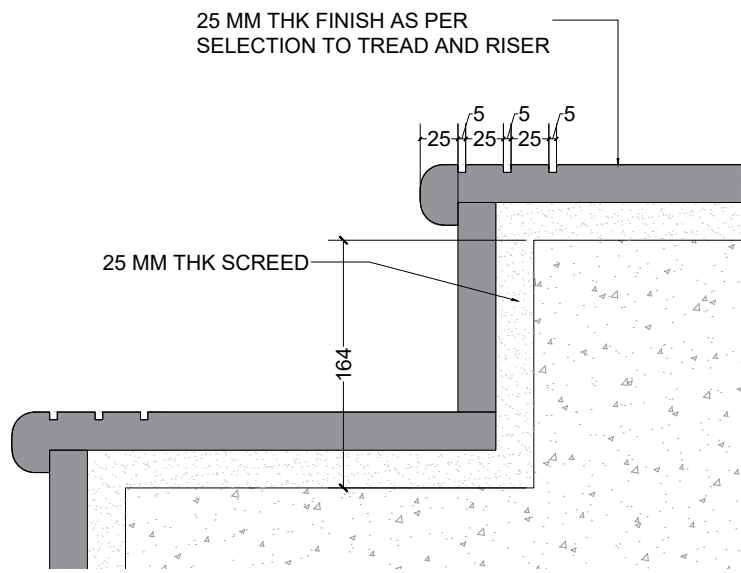

TYPICAL TREAD RISER DETAIL

 PPS-BV-A-501-R0		0.0.0
GENERAL NOTES: ALL DIMENSIONS SHOWN ARE IN MILLIMETERS ALL SURFACE LEVELS ARE SHOWN IN METERS THIS DRAWING SHALL NOT BE SCALED. WRITTEN DIMENSIONS SHALL BE FOLLOWED. DISCREPANCIES BETWEEN SITE CONDITION AND DATA SHOWN ON DRAWING SHALL BE BROUGHT TO THE NOTICE OF THE ARCHITECT PRIOR TO CONSTRUCTION WORKS.		
DRAWING NOTES: 1. THE INFORMATION ON THIS DRAWING SUPERCEDES INFORMATION IN OTHER DRAWINGS. 2. ALL THE EXISTING TREES NEED TO BE RETAIN AND TRIMMED.		
KEY PLAN :		
REV NO.	REVISION DETAILS	DATE
REVISION NOTES		
CONSULTANTS:		
STRUCTURAL CONSULTANT :  Associated Structural Engineers LLP. 607, Opal Square, Opp. Ralladevi Lake, Barve Rd. Wagale Estate, Thane (w) - 400 604. Phone : +91 22 2587 1209/4186, 6876072223 Email : info@asc.org.in Website : www.asc.org.in		
MEP CONSULTANT : M/s. Specialised Mep Engineering Consultants. Thane - West Email : specialisedmepconsultants@gmail.com		
SCALE: 1:150	DRAWN BY MEGHAL	
PAPER A2	CHECKED BY KALYANI	
DATE 17-10-2024	DRAWING TYPE : TENDER DRAWING	
DRAWING NAME:	STAIRCASE DETAIL	
REVISION NUMBER:	R0	
PROJECT NAME:	BAHURATNA VASUNDHARA - GUJARAT UNIVERSITY	
PROJECT NUMBER:		
ARCHITECT:	APICES STUDIO PVT. LTD.	
CLIENT NAME:	GUJARAT UNIVERSITY	
PROJECT ARCHITECTS		
		
APICES STUDIO PVT. LTD. 203,204,205,LODHA SUPREMUS, ROAD NO.22,WAGALE ESTATE, THANE WEST - 400604 TEL: +91 22 25870701/702/703/704		

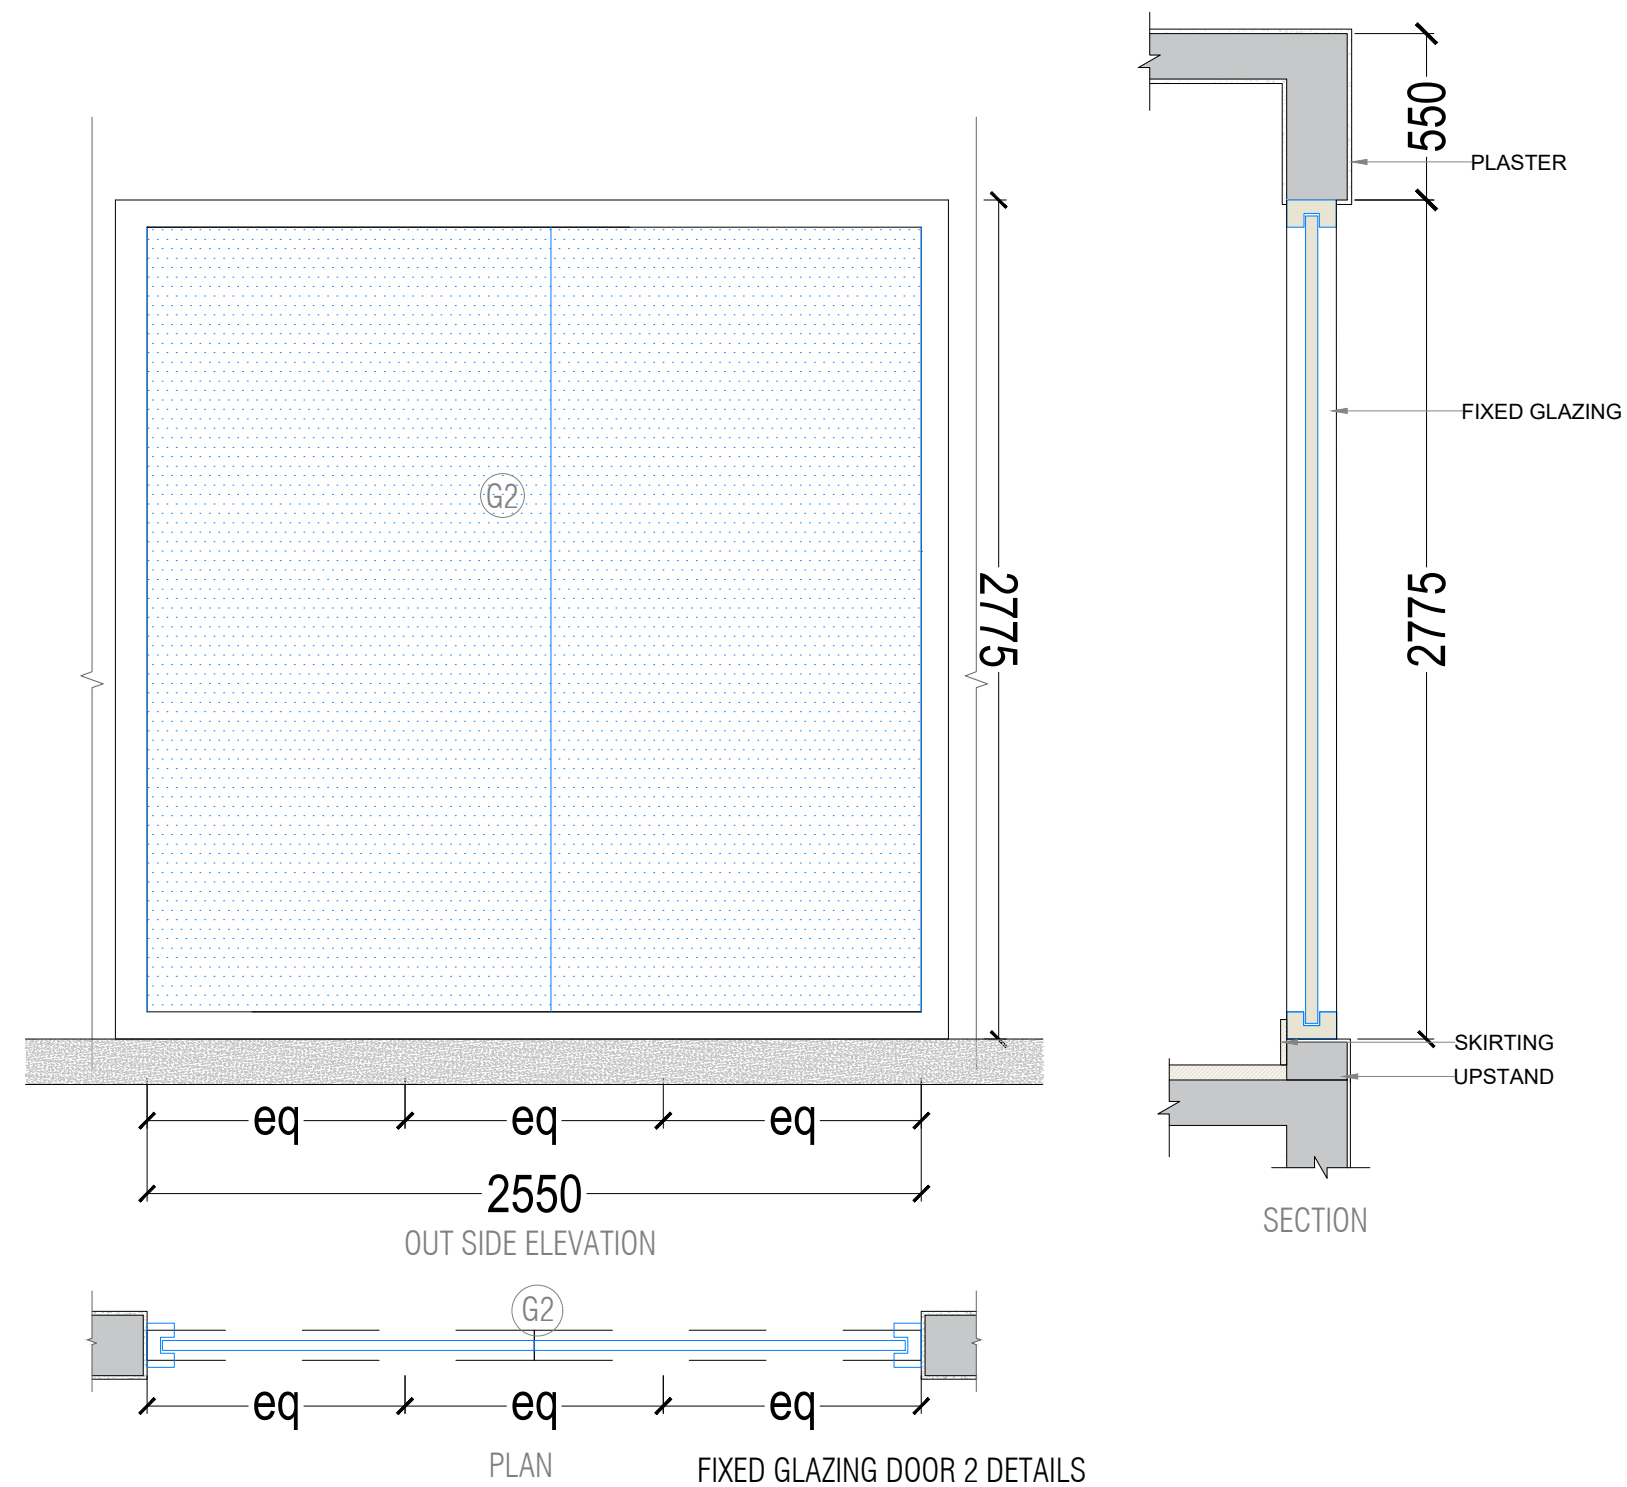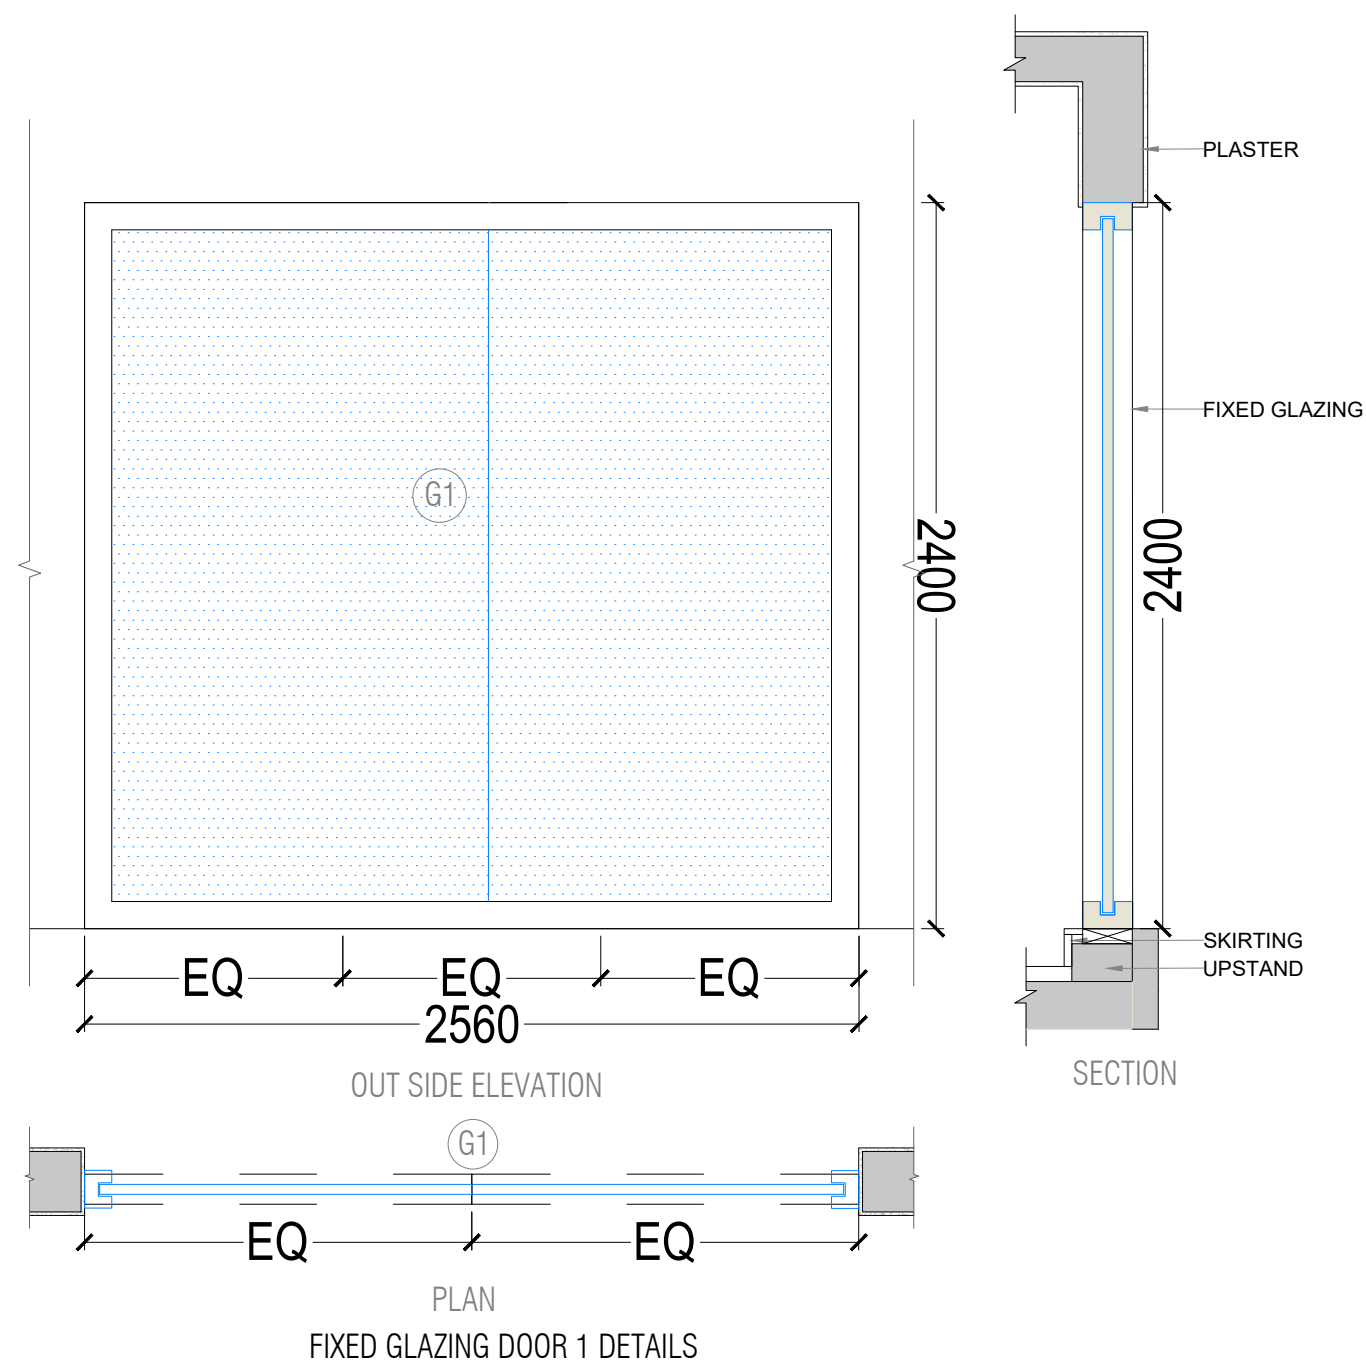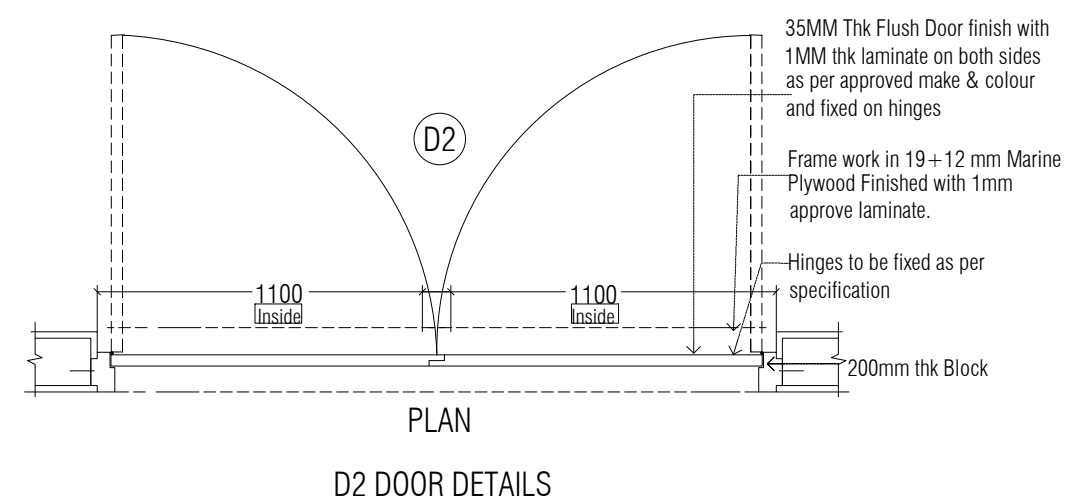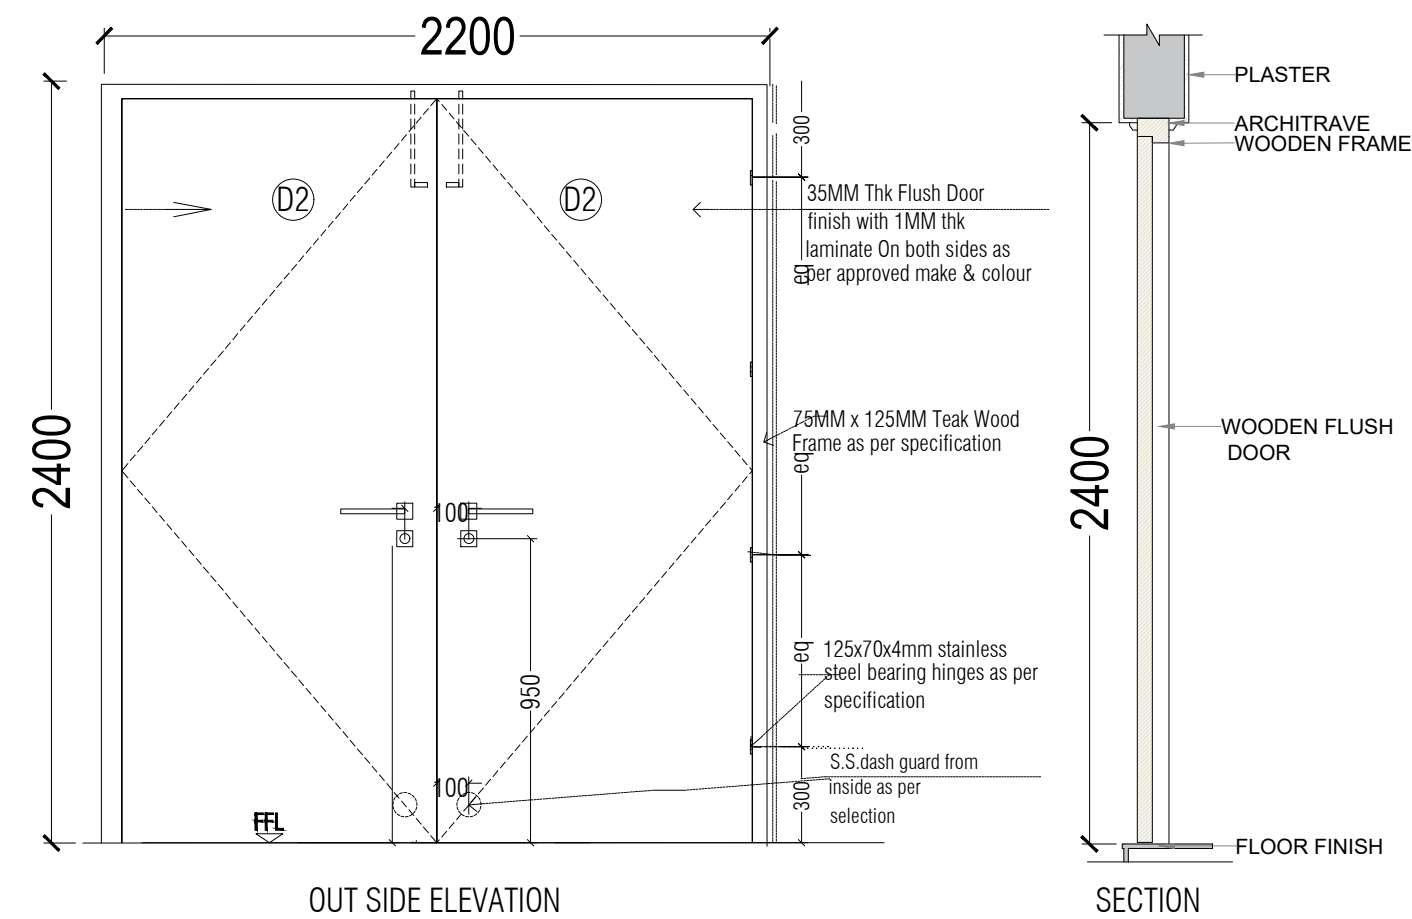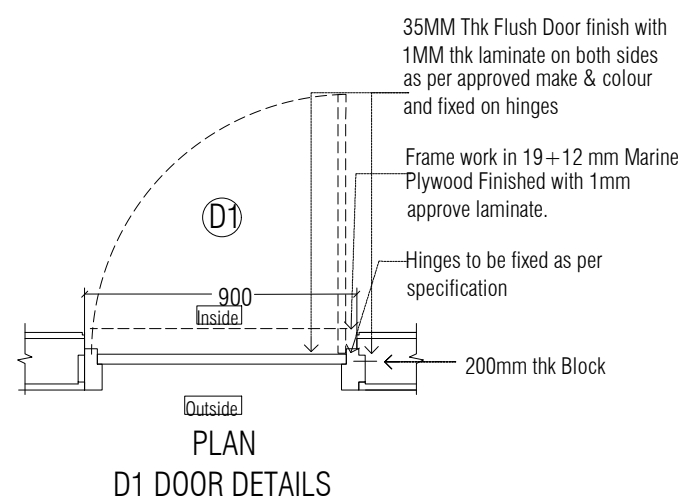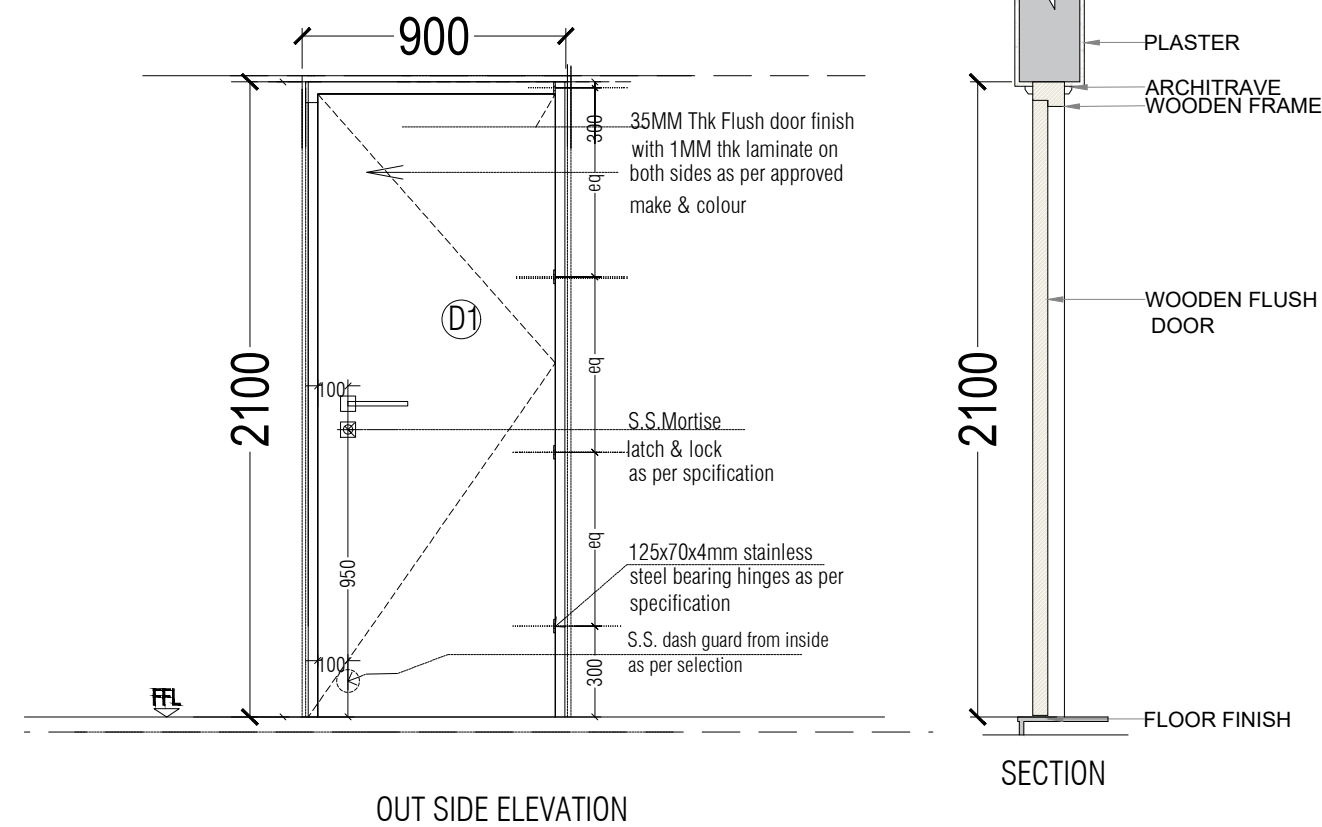

APS-BV-A-601-R0	0.0.0
-----------------	-------

GENERAL NOTES:
ALL DIMENSIONS SHOWN ARE IN MILLIMETERS
ALL SURFACE LEVELS ARE SHOWN IN METERS
THIS DRAWING SHALL NOT BE SCALED.
WRITTEN DIMENSIONS SHALL BE FOLLOWED.

DISCREPANCIES BETWEEN SITE CONDITION
AND DATA SHOWN ON DRAWING SHALL BE
BROUGHT TO THE NOTICE OF THE ARCHITECT
PRIOR TO CONSTRUCTION WORKS.

DRAWING NOTES:

1. THE INFORMATION ON THIS DRAWING SUPERCEDES INFORMATION IN OTHER DRAWINGS.
2. ALL THE EXISTING TREES NEED TO BE RETAIN AND TRIMMED.

KEY PLAN :

REV NO.	REVISION DETAILS	DATE
---------	------------------	------

REVISION NOTES

CONSULTANTS:

STRUCTURAL CONSULTANT :  **Associated Structural Engineers LLP.**
607, Opal Square, Opp. Railadevi Lake, Barve Rd. Wagale Estate
Thane (w)- 400 604.
Phone: +91-22-20812084/85, 8976072223
Email: info@asc.org.in Website: www.asc.org.in



MEP
CONSULTANT :
M/s. Specialised Mep
Engineering Consultants.
Thane - West
Email : specialisedmepconsultants@gmail.com

SCALE: 1:25	DRAWN BY CAKSHI	
	CHECKED BY KALYANI	
DRAWING TYPE: TENDER DRAWING		
DATING: 17-10-2024	DRAWING NAME: DOOR DETAILS	
REVISION NUMBER: R0	PROJECT NAME: BAHURATNA VASUNDHARA - GUJARAT UNIVERSITY	
PROJECT NUMBER: (Empty)	ARCHITECT: APICES STUDIO PVT. LTD.	
CLIENT NAME: GUJARAT UNIVERSITY	(Empty)	

PROJECT ARCHITECTS



APICES STUDIO PVT. LTD.
203,204,205,LODHA SUPREMAS,
ROAD NO.22,WAGALE ESTATE,
THANE WEST - 400604
TEL: +91 22 25870701/702/703/704

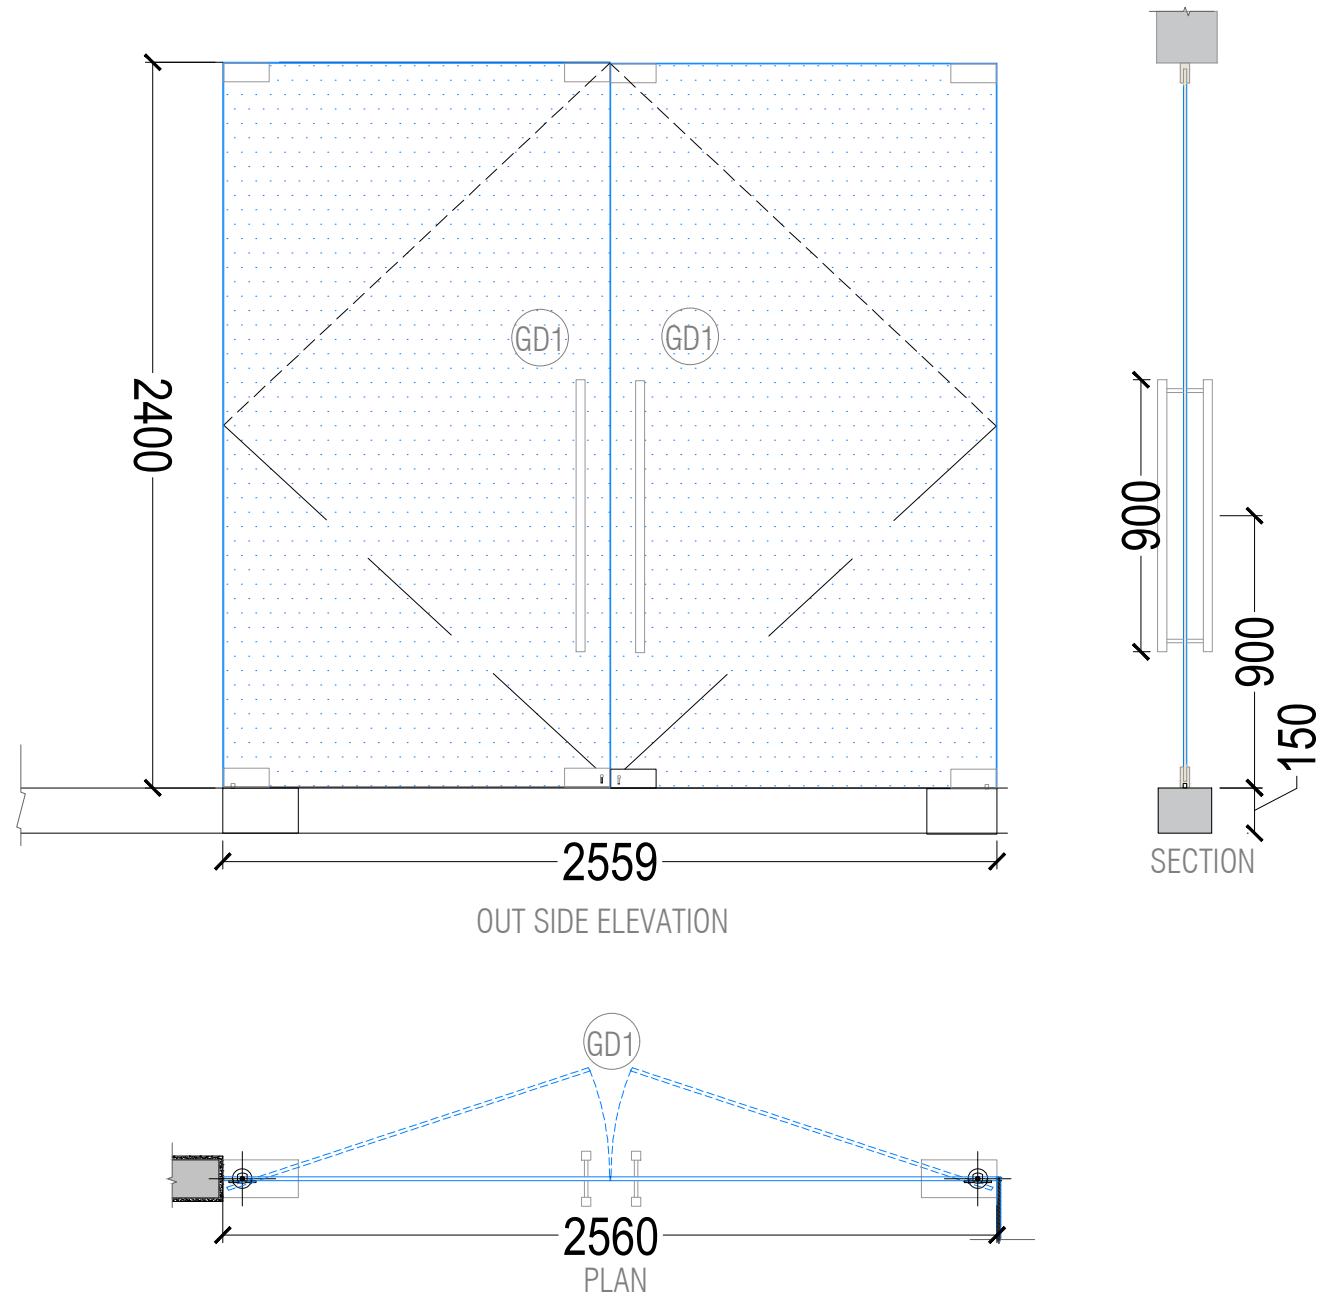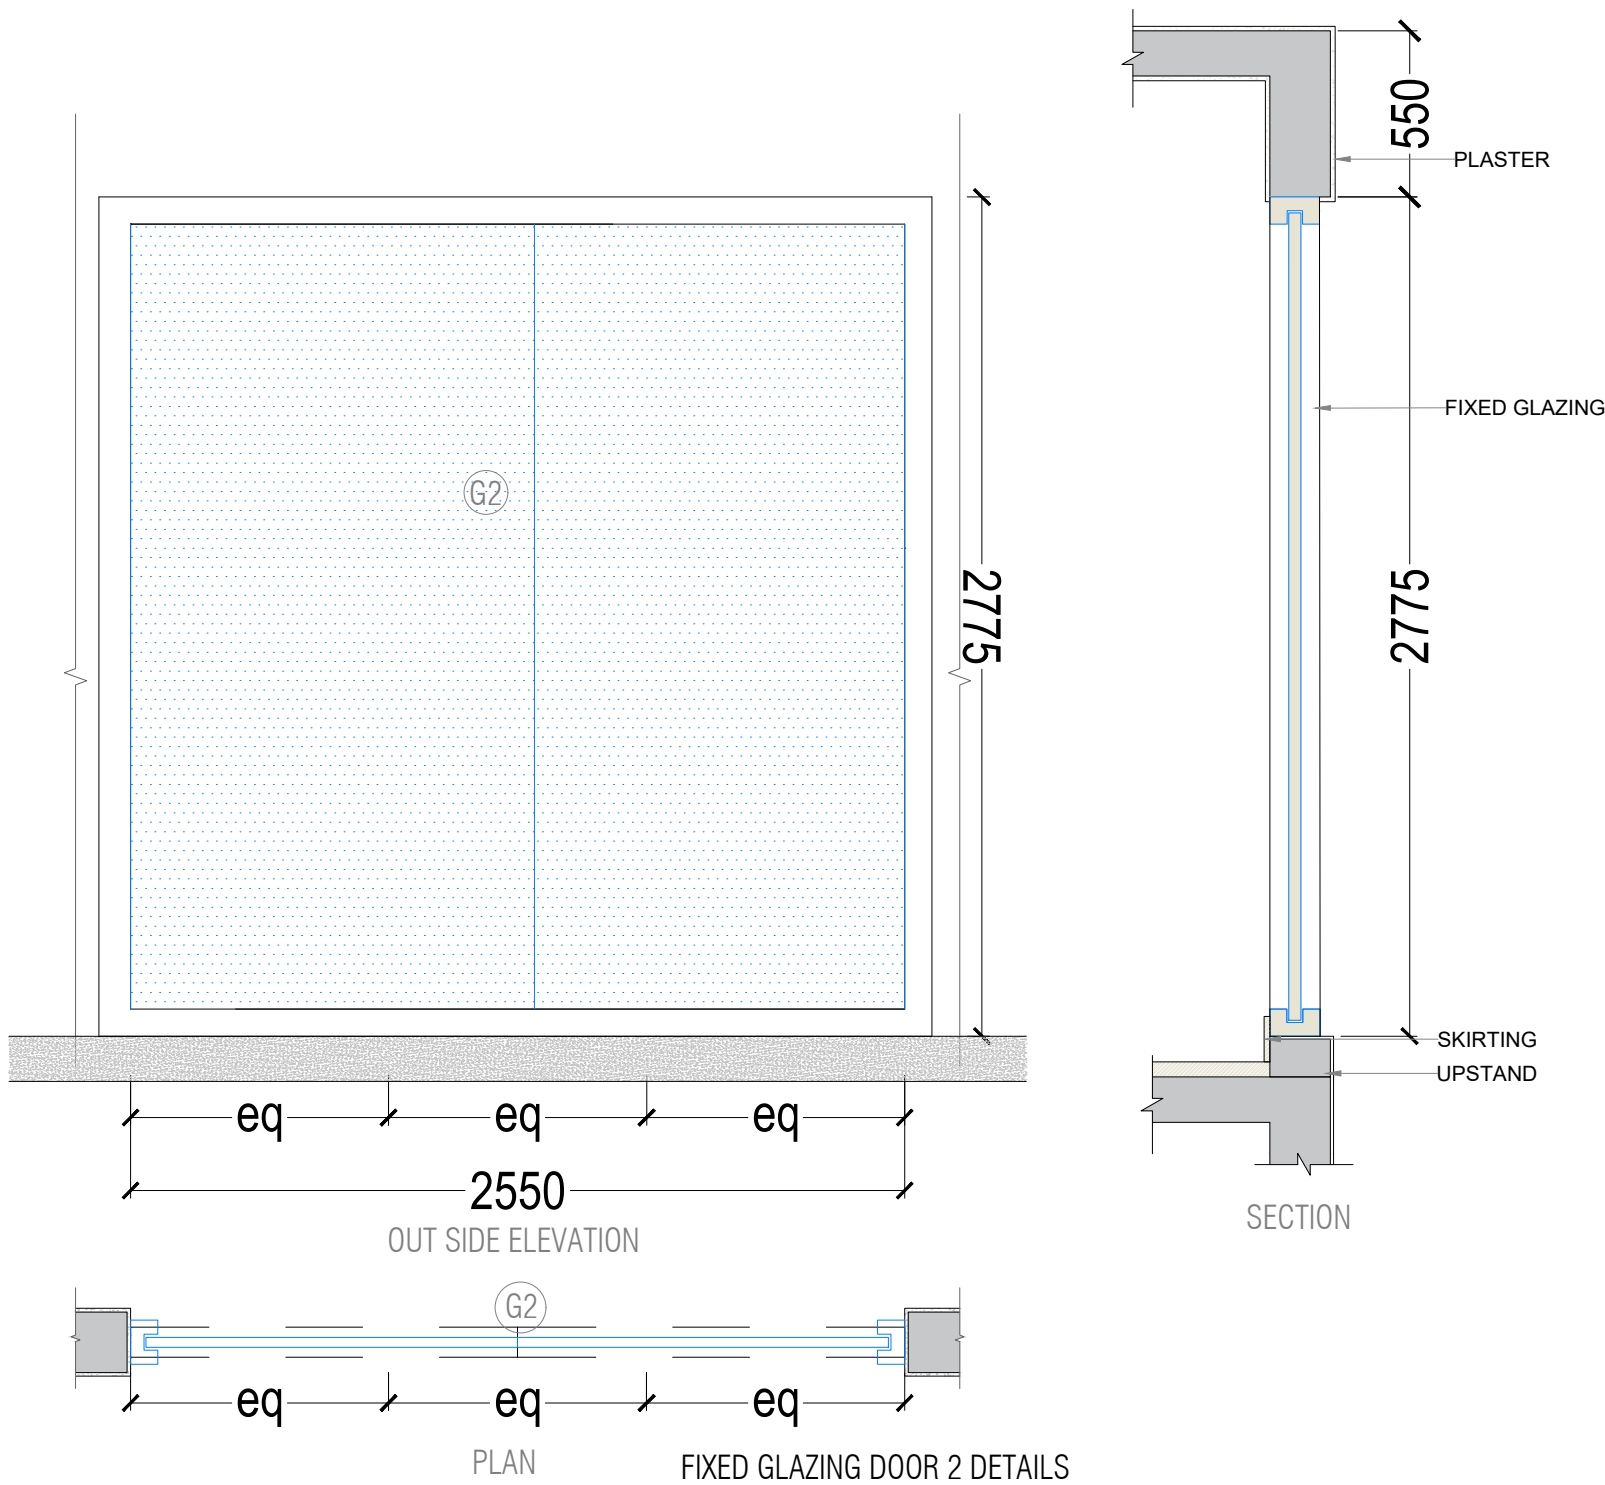

GLAZING DOOR 1 DETAILS

GENERAL NOTES:
ALL DIMENSIONS SHOWN ARE IN MILLIMETERS
ALL SURFACE LEVELS ARE SHOWN IN METERS
THIS DRAWING SHALL NOT BE SCALED.
WRITTEN DIMENSIONS SHALL BE FOLLOWED.

DISCREPANCIES BETWEEN SITE CONDITION AND
DATA SHOWN ON DRAWING SHALL BE
BROUGHT TO THE NOTICE OF THE ARCHITECT
PRIOR TO CONSTRUCTION WORKS.

DRAWING NOTES:
1. THE INFORMATION ON THIS DRAWING
SUPERCEDES INFORMATION IN OTHER DRAWINGS.
2. ALL THE EXISTING TREES NEED TO BE RETAIN AND
TRIMMED.

KEY PLAN :


REV NO.	REVISION DETAILS	DATE

REVISION NOTES

CONSULTANTS:

STRUCTURAL CONSULTANT :  Associated Structural Engineers LLP.
607, Opal Square, Opp. Ralladevi Lake, Barve Rd. Wagale Estate, Thane (w) - 400 604.
Phone: +91-22-25812084/85, 8976072223
Email: info@asc.org.in Website: www.asc.org.in

 
MEP CONSULTANT :
M/s. Specialised Mep Engineering Consultants.
Thane - West
Email : specialisedmepconsultants@gmail.com

SCALE: 1:25	DRAWN BY SAKSHI	
PAPER A2	CHECKED BY KALYANI	
DATE 17-10-2024	DRAWING TYPE : TENDER DRAWING	
DRAWING NAME:	DOOR DETAILS	
REVISION NUMBER:	R0	
PROJECT NAME:	BAHURATNA VASUNDHARA - GUJARAT UNIVERSITY	
PROJECT NUMBER:		
ARCHITECT:	APICES STUDIO PVT. LTD.	
CLIENT NAME:	GUJARAT UNIVERSITY	


PROJECT ARCHITECTS




APICES STUDIO PVT. LTD.
203,204,205,LODHA SUPREMUS,
ROAD NO.22,WAGALE ESTATE,
THANE WEST - 400604
TEL: +91 22 25870701/702/703/704

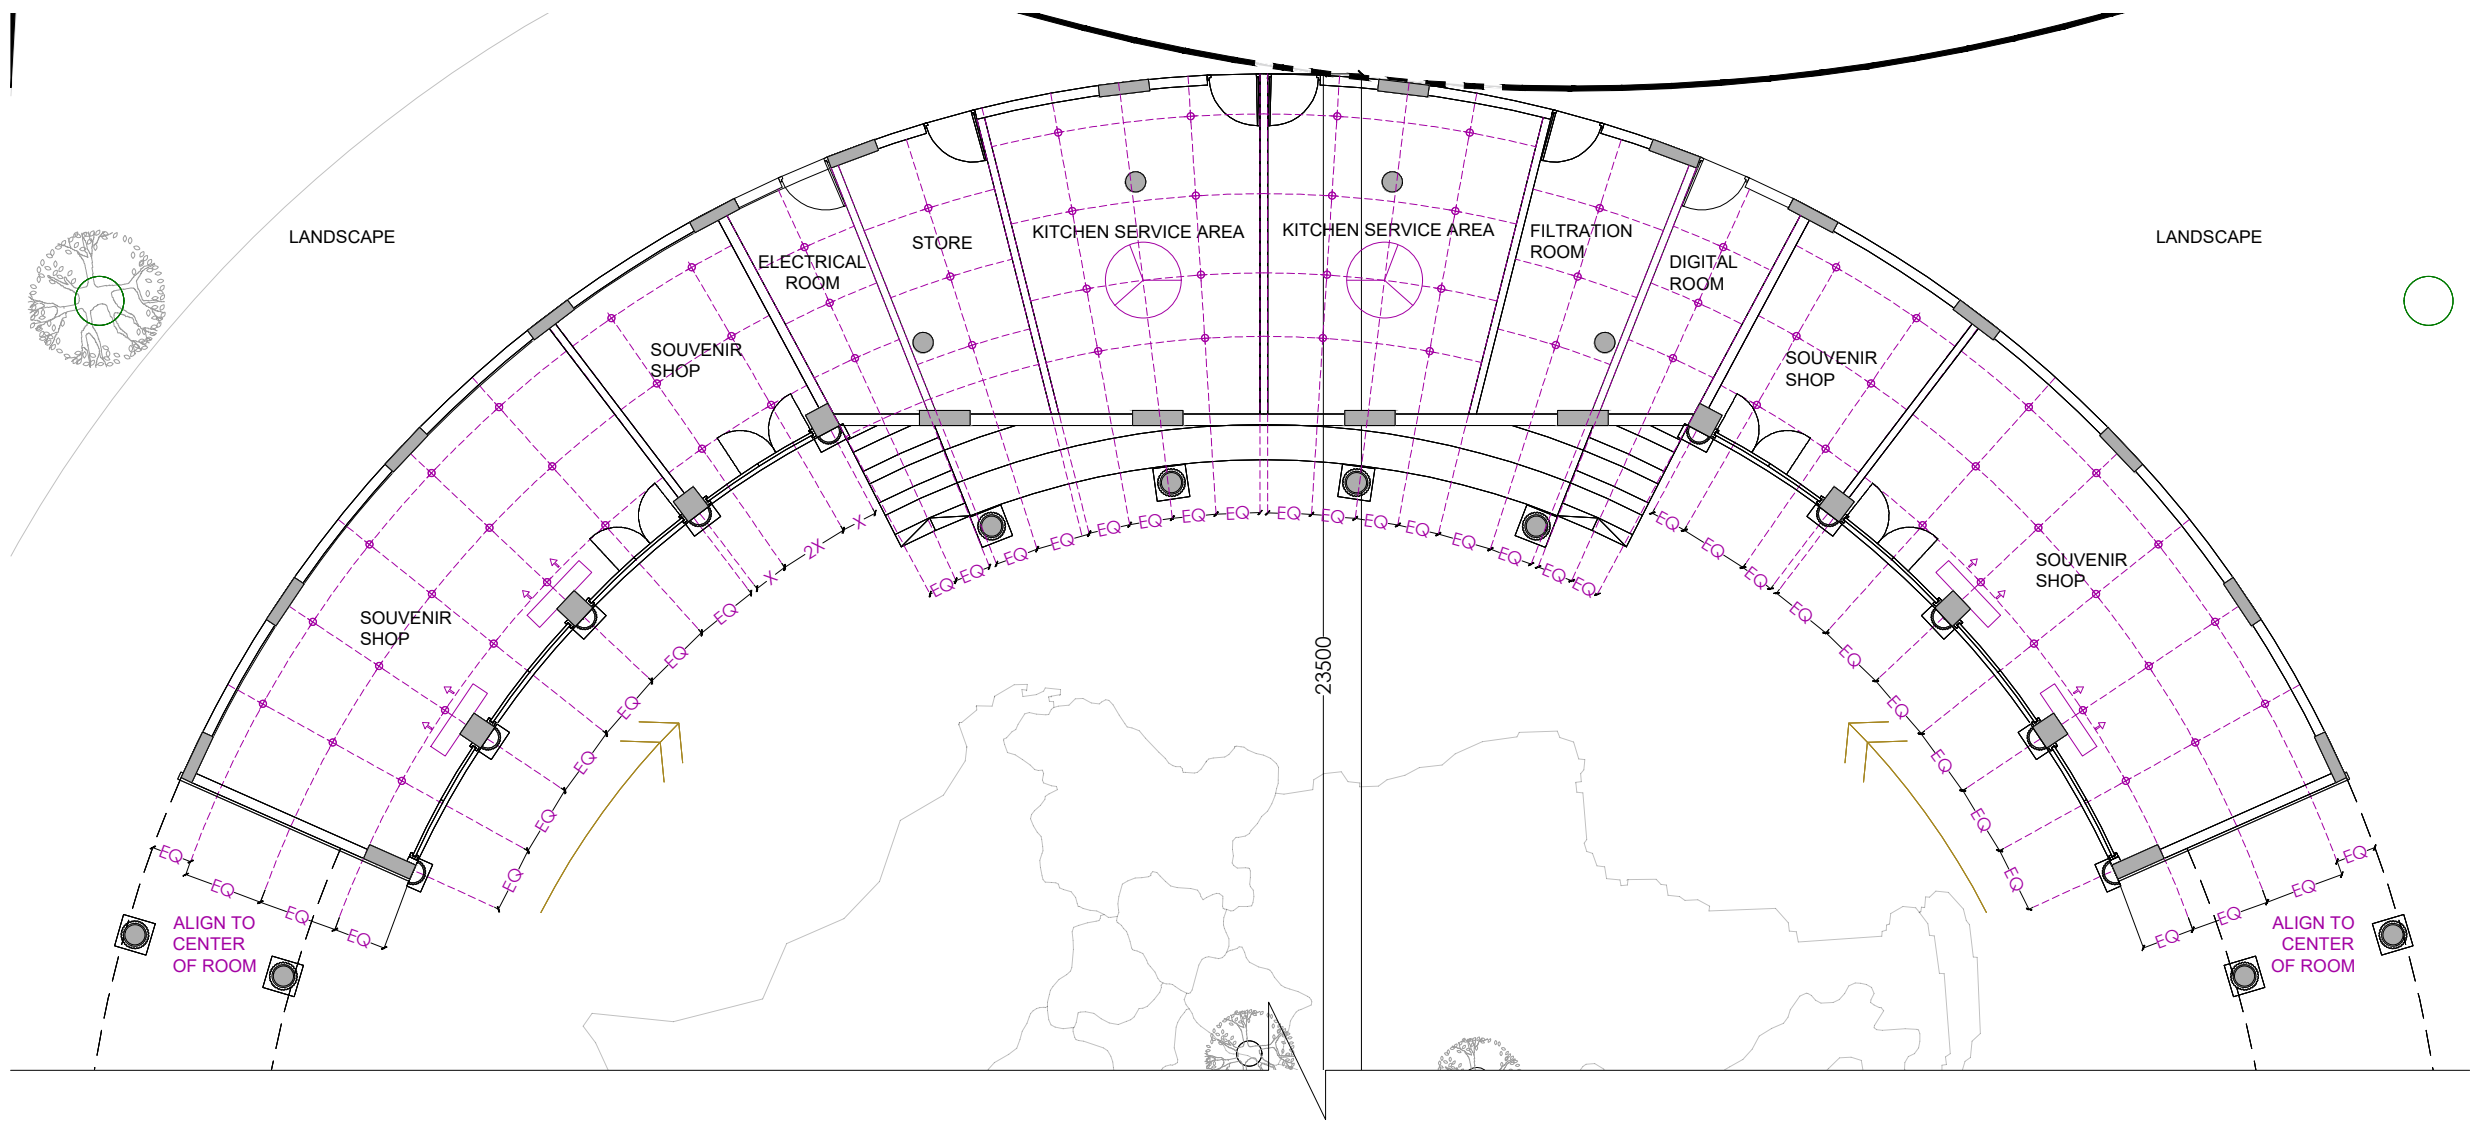

GROUND FLOOR PLAN

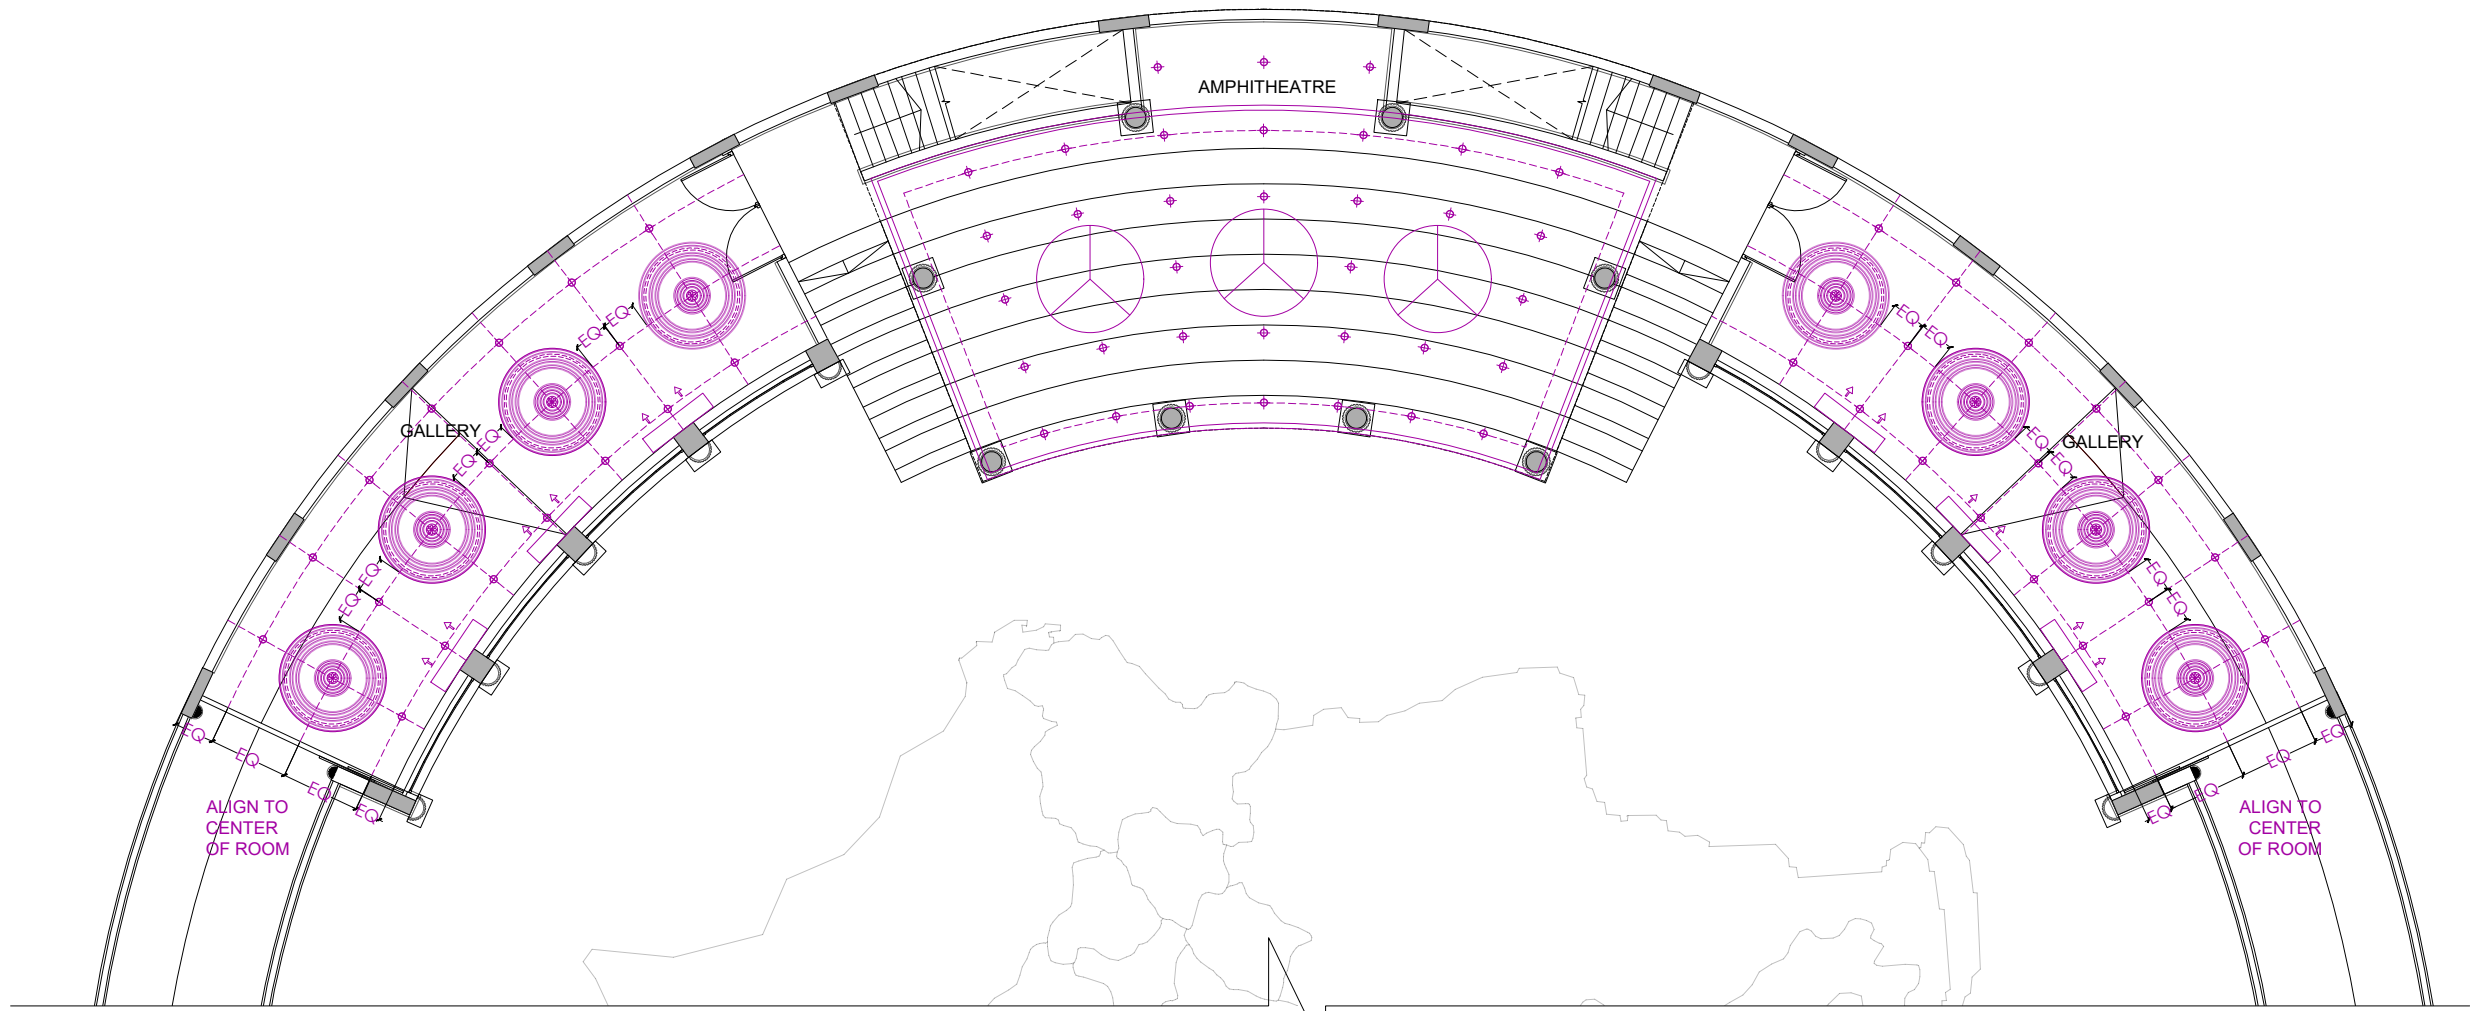

FIRST FLOOR PLAN

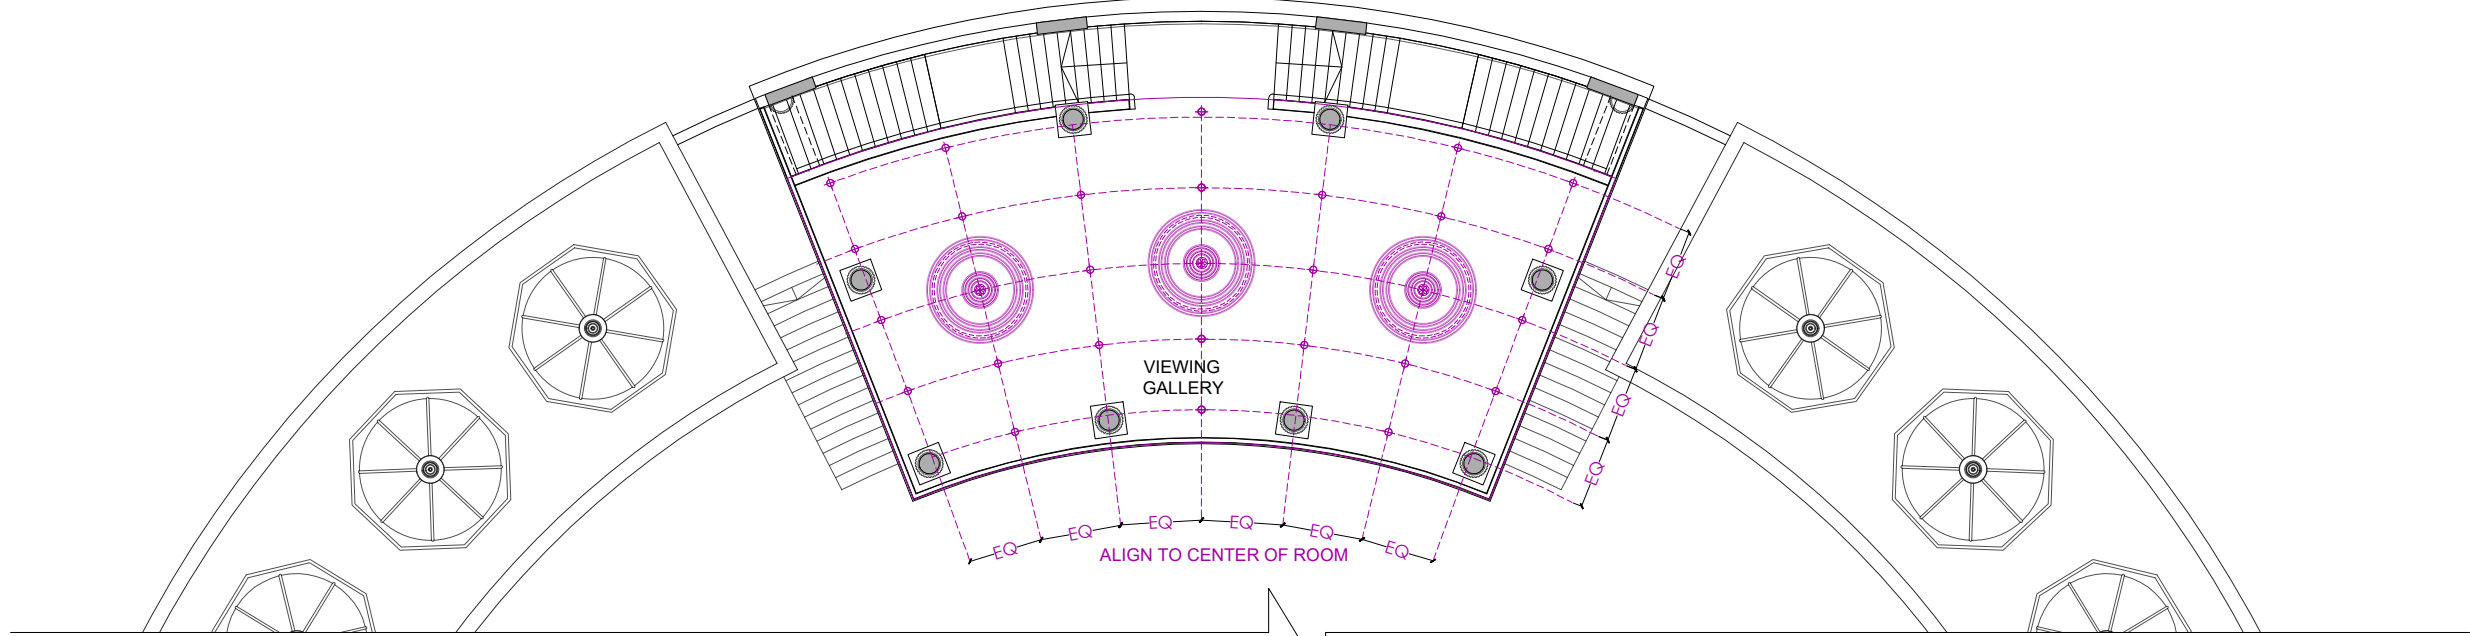

VIEWING GALLERY PLAN

LEGENDS	
	LIGHT IN CEILING
	CEILING FAN
	AIR CONDITIONING
	MOTIF IN CEILING

APS-BV-A-701-R0

0.0.0

GENERAL NOTES:
ALL DIMENSIONS SHOWN ARE IN MILLIMETERS
ALL SURFACE LEVELS ARE SHOWN IN METERS
THIS DRAWING SHALL NOT BE SCALED.
WRITTEN DIMENSIONS SHALL BE FOLLOWED.

DISCREPANCIES BETWEEN SITE CONDITION AND
DATA SHOWN ON DRAWING SHALL BE
BROUGHT TO THE NOTICE OF THE ARCHITECT
PRIOR TO CONSTRUCTION WORKS.

DRAWING NOTES:
1. THE INFORMATION ON THIS DRAWING
SUPERCEDES INFORMATION IN OTHER DRAWINGS.
2. ALL THE EXISTING TREES NEED TO BE RETAIN AND
TRIMMED.

KEY PLAN :


REV NO.	REVISION DETAILS	DATE
---------	------------------	------

REVISION NOTES

CONSULTANTS:

STRUCTURAL
CONSULTANT : Associated Structural
Engineers LLP.
607, Opal Square, Opp. Ralladevi Lake, Barve Rd. Wagale Estate,
Thane (w) - 400 604.
Phone: +91-22-25812084/85, 8976072223
Email: info@asc.org.in Website: www.asc.org.in

 MEP
CONSULTANT :
M/s. Specialised Mep
Engineering Consultants.
Thane - West
Email : specialisedmepconsultants@gmail.com

SCALE: 1:150	DRAWN BY SHRADDHA	
PAPER A2	CHECKED BY KALYANI	
DATE 17-10-2024	DRAWING TYPE : TENDER DRAWING	
DRAWING NAME:	REFLECTED CEILING PLAN	
REVISION NUMBER:	R0	
PROJECT NAME:	BAHURATNA VASUNDHARA - GUJARAT UNIVERSITY	
PROJECT NUMBER:		
ARCHITECT:	APICES STUDIO PVT. LTD.	
CLIENT NAME:	GUJARAT UNIVERSITY	

PROJECT ARCHITECTS



APICES STUDIO PVT. LTD.
203,204,205,LODHA SUPREMUS,
ROAD NO.22,WAGALE ESTATE,
THANE WEST - 400604
TEL: +91 22 25870701/702/703/704

Architectural elevation drawing of a classical archway. The structure features two fluted columns supporting a decorative arch. The arch is filled with a light orange color and contains a central semi-circular opening. The drawing includes various dimensions and section markers.

Dimensions:

- Overall height: 4850
- Overall width: 600
- Arch height (from column top): 1400
- Arch width (from column top): 550
- Arch opening height: 300
- Arch opening width: 375
- Arch opening radius: 300
- Arch opening depth: 200
- Column diameter: 225
- Column base width: 130
- Column base height: 100

Section Markers:

- AA SECTION (indicated on both sides of the arch)

Architectural elevation drawing of a building facade. The central feature is a large arched window with an orange-tinted interior. The window is flanked by two columns with vertical fluting. Above the window is a decorative horizontal band. The overall height of the facade is 1950. The window opening is 2500 wide and 2300 high. The arch of the window has a radius of 1250. The window is set within a frame that is 760 wide and 550 high. The columns are 150 wide and 150 high. The drawing includes various other dimensions for the window's internal features and the building's overall proportions.

Technical drawing of a dome structure. The drawing shows a dome with a central finial. Dimensions are provided in millimeters (mm):

- Overall height: 3065 mm
- Height from base to the top of the dome: 1710 mm
- Height from base to the top of the finial: 910 mm
- Base diameter: 4815 mm
- Base thickness: 100 mm
- Base width (excluding base thickness): 350 mm

Technical drawing of a circular hatch cover with an octagonal frame. The drawing shows a central circular hub with eight radial spokes. The outer frame is an octagon. Dimensions are provided: the overall width is 4815, the width of the octagonal frame is 4300, and the height of the octagonal frame is 1995.

Technical drawing of the dome structure of the 'L' building, showing a cross-section with dimensions and labels:

- 540
- METAL PLATE
- GRC DOME
- 1335
- METAL PLATE
- 450
- PEDESTAL

Technical drawing of a dome structure. The dome has a total height of 590 units. The main dome body has a height of 1120 units. The base of the dome is 3150 units wide. The base of the dome is 65 units high. The base of the dome is divided into 12 segments.

DOME PLAN


(TITLE-2)

Architectural drawing of the front elevation of a column. The column is divided into three main sections: a base (1), a shaft (2), and a capital. The base is 650 wide and 150 high. The shaft is 550 wide and 4850 high. The capital is 800 wide and 1950 high. The total height is 6600. The drawing includes dimensions for the base, shaft, and capital, as well as the overall height and width.


UMN TY

Diagram of a square with a semi-circular cutout at the bottom center. The square has a side length of 500. The cutout is a semi-circle with a diameter of 500. The width of the base is labeled as 650.

1-R0		0.0.0	
SHOWN ARE IN MILLIMETERS ELS ARE SHOWN IN METERS HALL NOT BE SCALED. IONS SHALL BE FOLLOWED.			
BETWEEN SITE CONDITION AND DRAWING SHALL BE NOTICE OF THE ARCHITECT DUCTION WORKS.			
3: ATION ON THIS DRAWING FORMATION IN OTHER DRAWINGS. TING TREES NEED TO BE RETAIN AND			
REVISION DETAILS		DATE	
REVISION NOTES			
CONSULTANTS:			
 Associated Structural Engineers LLP. Office: Opp. Paladevi Lake, Barve Rd. Wagale Estate, Thane (w) - 400 604. Phone: +91-22-20812084/85, 8976072223 Email: info@asc.org.in Website: www.asc.org.in			
: _____ ed Mep onsultants. isedmepconsultants@gmail.com			
DRAWN BY SAKSHI			
CHECKED BY KALYANI			
DRAWING TYPE : TENDER DRAWING			
GRC DETAILS			
R0			
BAHURATNA VASUNDHARA - GUJARAT UNIVERSITY			
APICES STUDIO PVT. LTD.			
GUJARAT UNIVERSITY			
ECT ARCHITECTS			
			
APICES udio pvt. ltd.			
S STUDIO PVT. LTD. 4,205,LODHA SUPREMUS, NO.22,WAGALE ESTATE, IANE WEST - 400604 22 25870701/702/703/704			

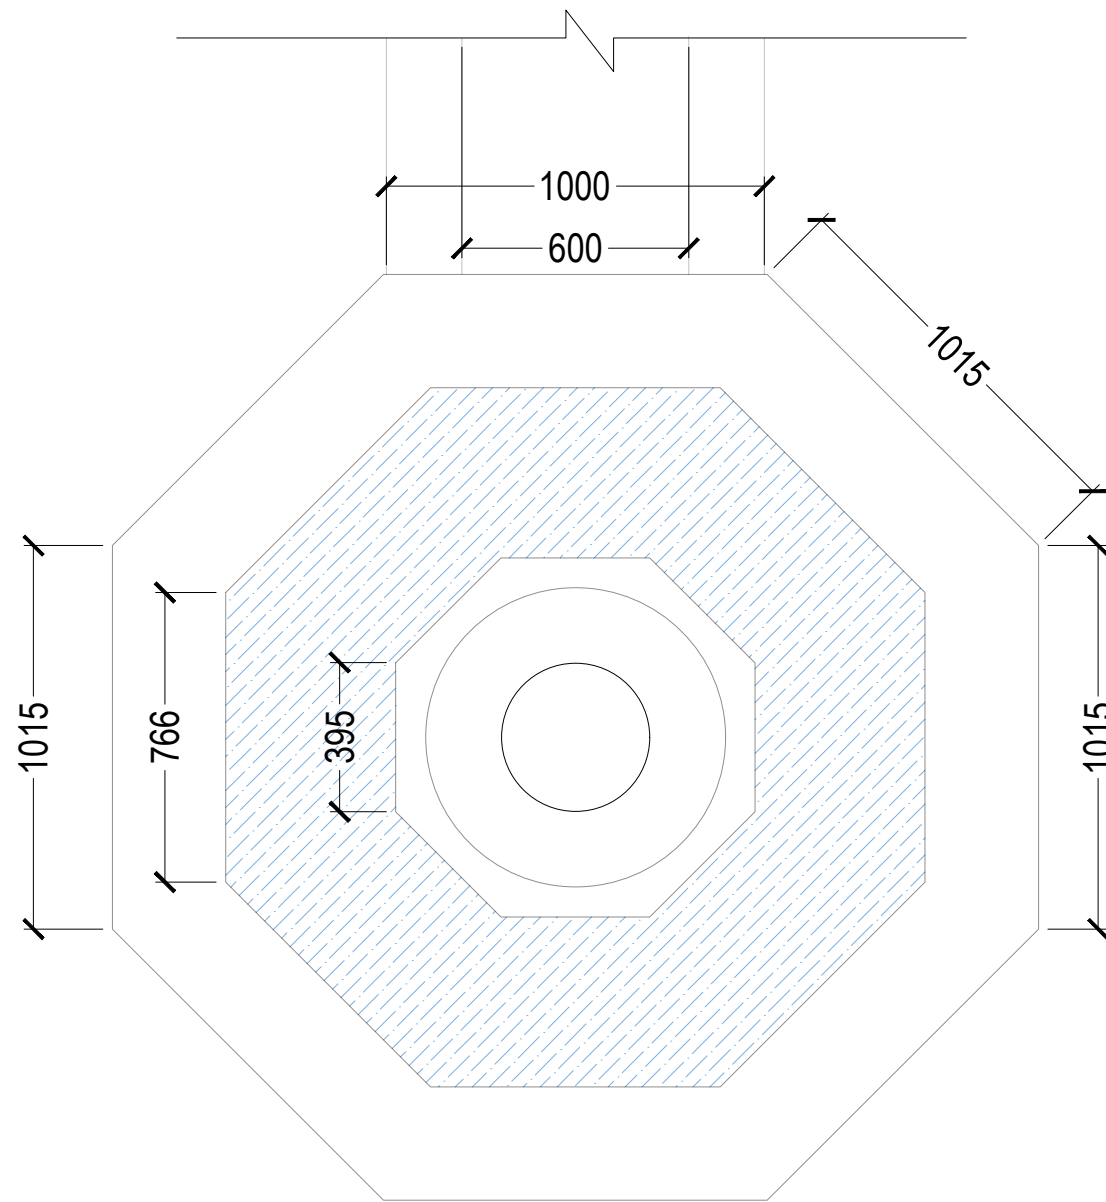

PLAN

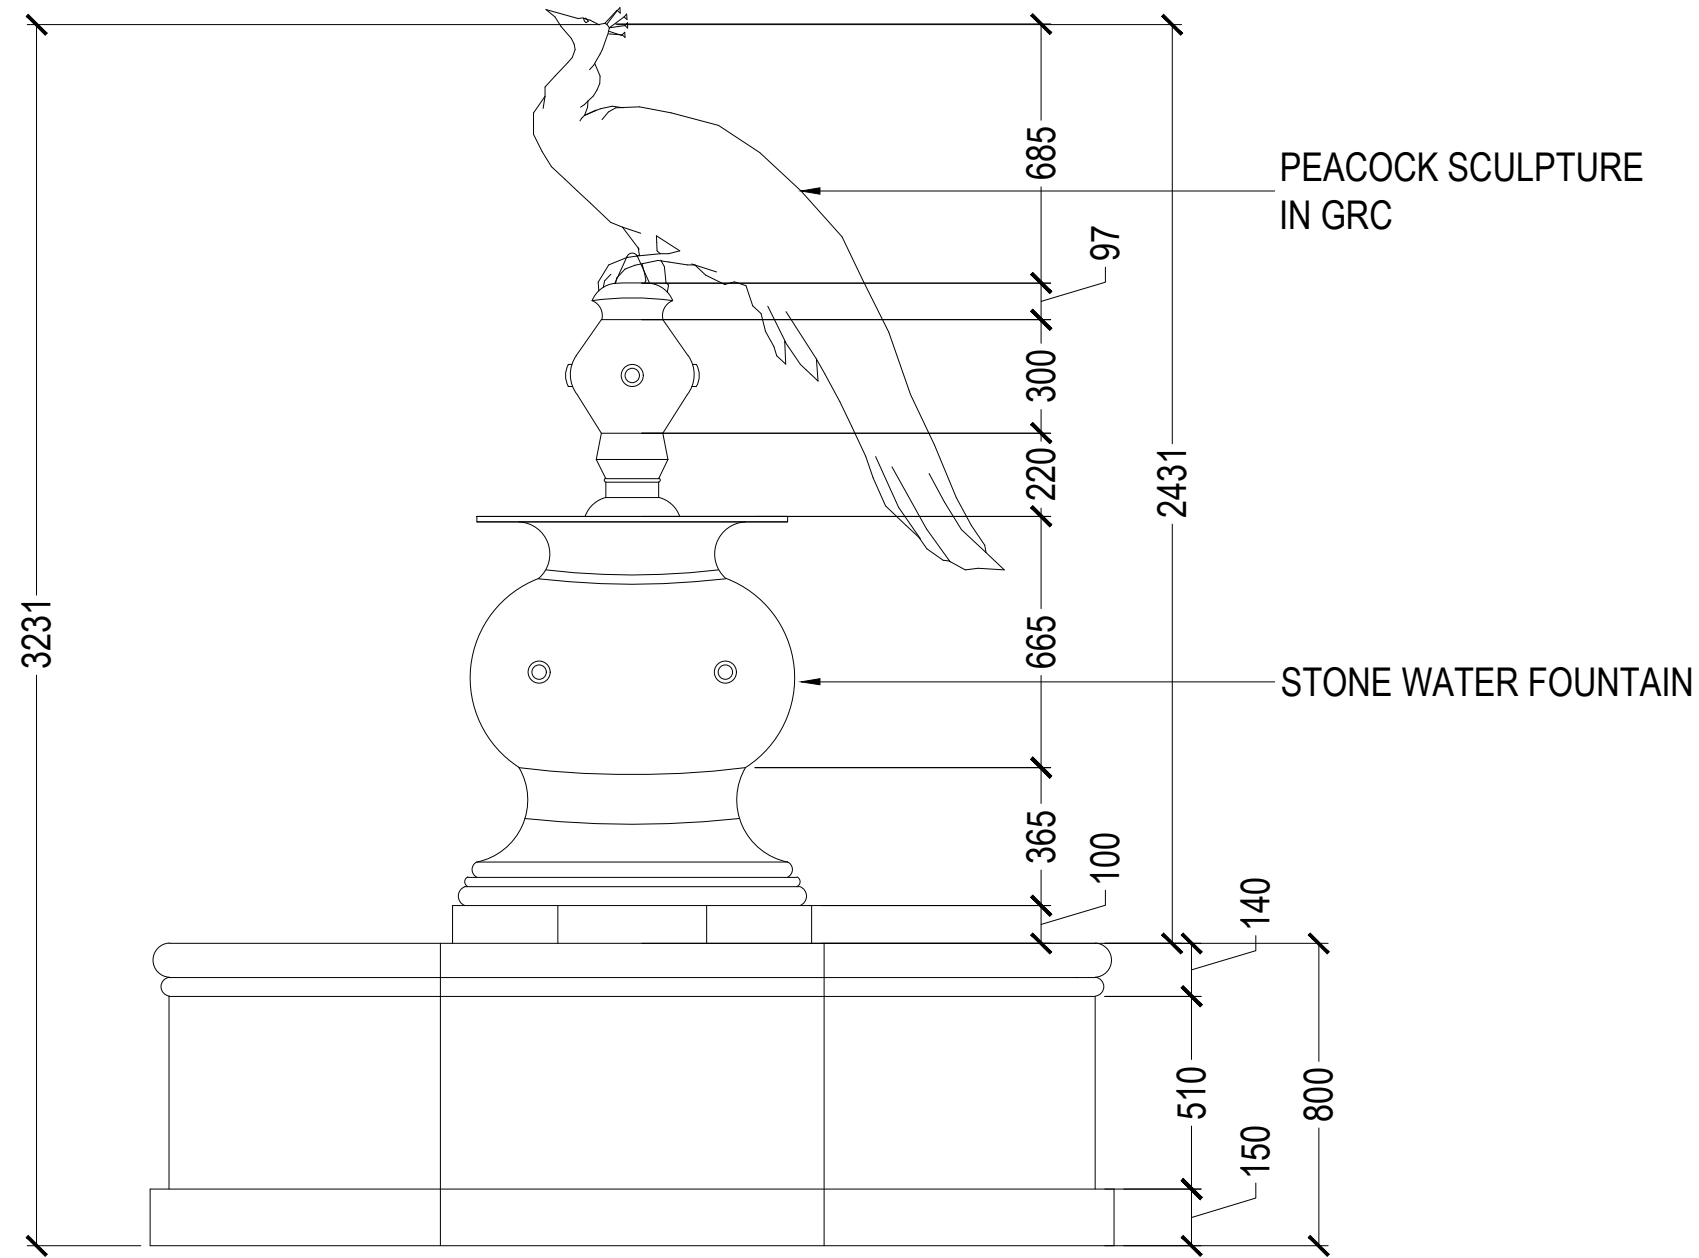

ELEVATION

APS-BV-A-808-R0

0.0.0

GENERAL NOTES:
ALL DIMENSIONS SHOWN ARE IN MILLIMETERS
ALL SURFACE LEVELS ARE SHOWN IN METERS
THIS DRAWING SHALL NOT BE SCALED.
WRITTEN DIMENSIONS SHALL BE FOLLOWED.

DISCREPANCIES BETWEEN SITE CONDITION AND DATA SHOWN ON DRAWING SHALL BE BROUGHT TO THE NOTICE OF THE ARCHITECT PRIOR TO CONSTRUCTION WORKS.

DRAWING NOTES:
1. THE INFORMATION ON THIS DRAWING SUPERCEDES INFORMATION IN OTHER DRAWINGS.
2. ALL THE EXISTING TREES NEED TO BE RETAIN AND TRIMMED.

KEY PLAN :

REV NO.	REVISION DETAILS	DATE

REVISION NOTES

CONSULTANTS:

 
STRUCTURAL CONSULTANT :



Associated Structural Engineers LLP.
607, Opal Square, Opp. Ralladevi Lake, Barve Rd. Wagale Estate, Thane (w) - 400 604.
Phone: +91-22-25812084/85, 8976072223
Email: info@asc.org.in Website: www.asc.org.in

MEP CONSULTANT :

M/s. Specialised Mep Engineering Consultants.
Thane - West
Email : specialisedmepconsultants@gmail.com

SCALE: 1:20	DRAWN BY SAKSHI	
PAPER A2	CHECKED BY KALYANI	
DATE 17-10-2024	DRAWING TYPE : TENDER DRAWING	

DRAWING NAME:	WATERBODY DETAILS
REVISION NUMBER:	R0
PROJECT NAME:	BAHURATNA VASUNDHARA - GUJARAT UNIVERSITY
PROJECT NUMBER:	
ARCHITECT:	APICES STUDIO PVT. LTD.
CLIENT NAME:	GUJARAT UNIVERSITY

PROJECT ARCHITECTS



APICES
studio pvt. ltd.

APICES STUDIO PVT. LTD.


203,204,205,LODHA SUPREMUS,
ROAD NO.22,WAGALE ESTATE,
THANE WEST - 400604
TEL: +91 22 25870701/702/703/704

GENERAL NOTES:
ALL DIMENSIONS SHOWN ARE IN MILLIMETERS
ALL SURFACE LEVELS ARE SHOWN IN METERS
THIS DRAWING SHALL NOT BE SCALED.
WRITTEN DIMENSIONS SHALL BE FOLLOWED.

DISCREPANCIES BETWEEN SITE CONDITION AND
DATA SHOWN ON DRAWING SHALL BE
BROUGHT TO THE NOTICE OF THE ARCHITECT
PRIOR TO CONSTRUCTION WORKS.

DRAWING NOTES:
1. THE INFORMATION ON THIS DRAWING
SUPERCEDES INFORMATION IN OTHER DRAWINGS.
2. ALL THE EXISTING TREES NEED TO BE RETAIN AND
TRIMMED.

KEY PLAN :

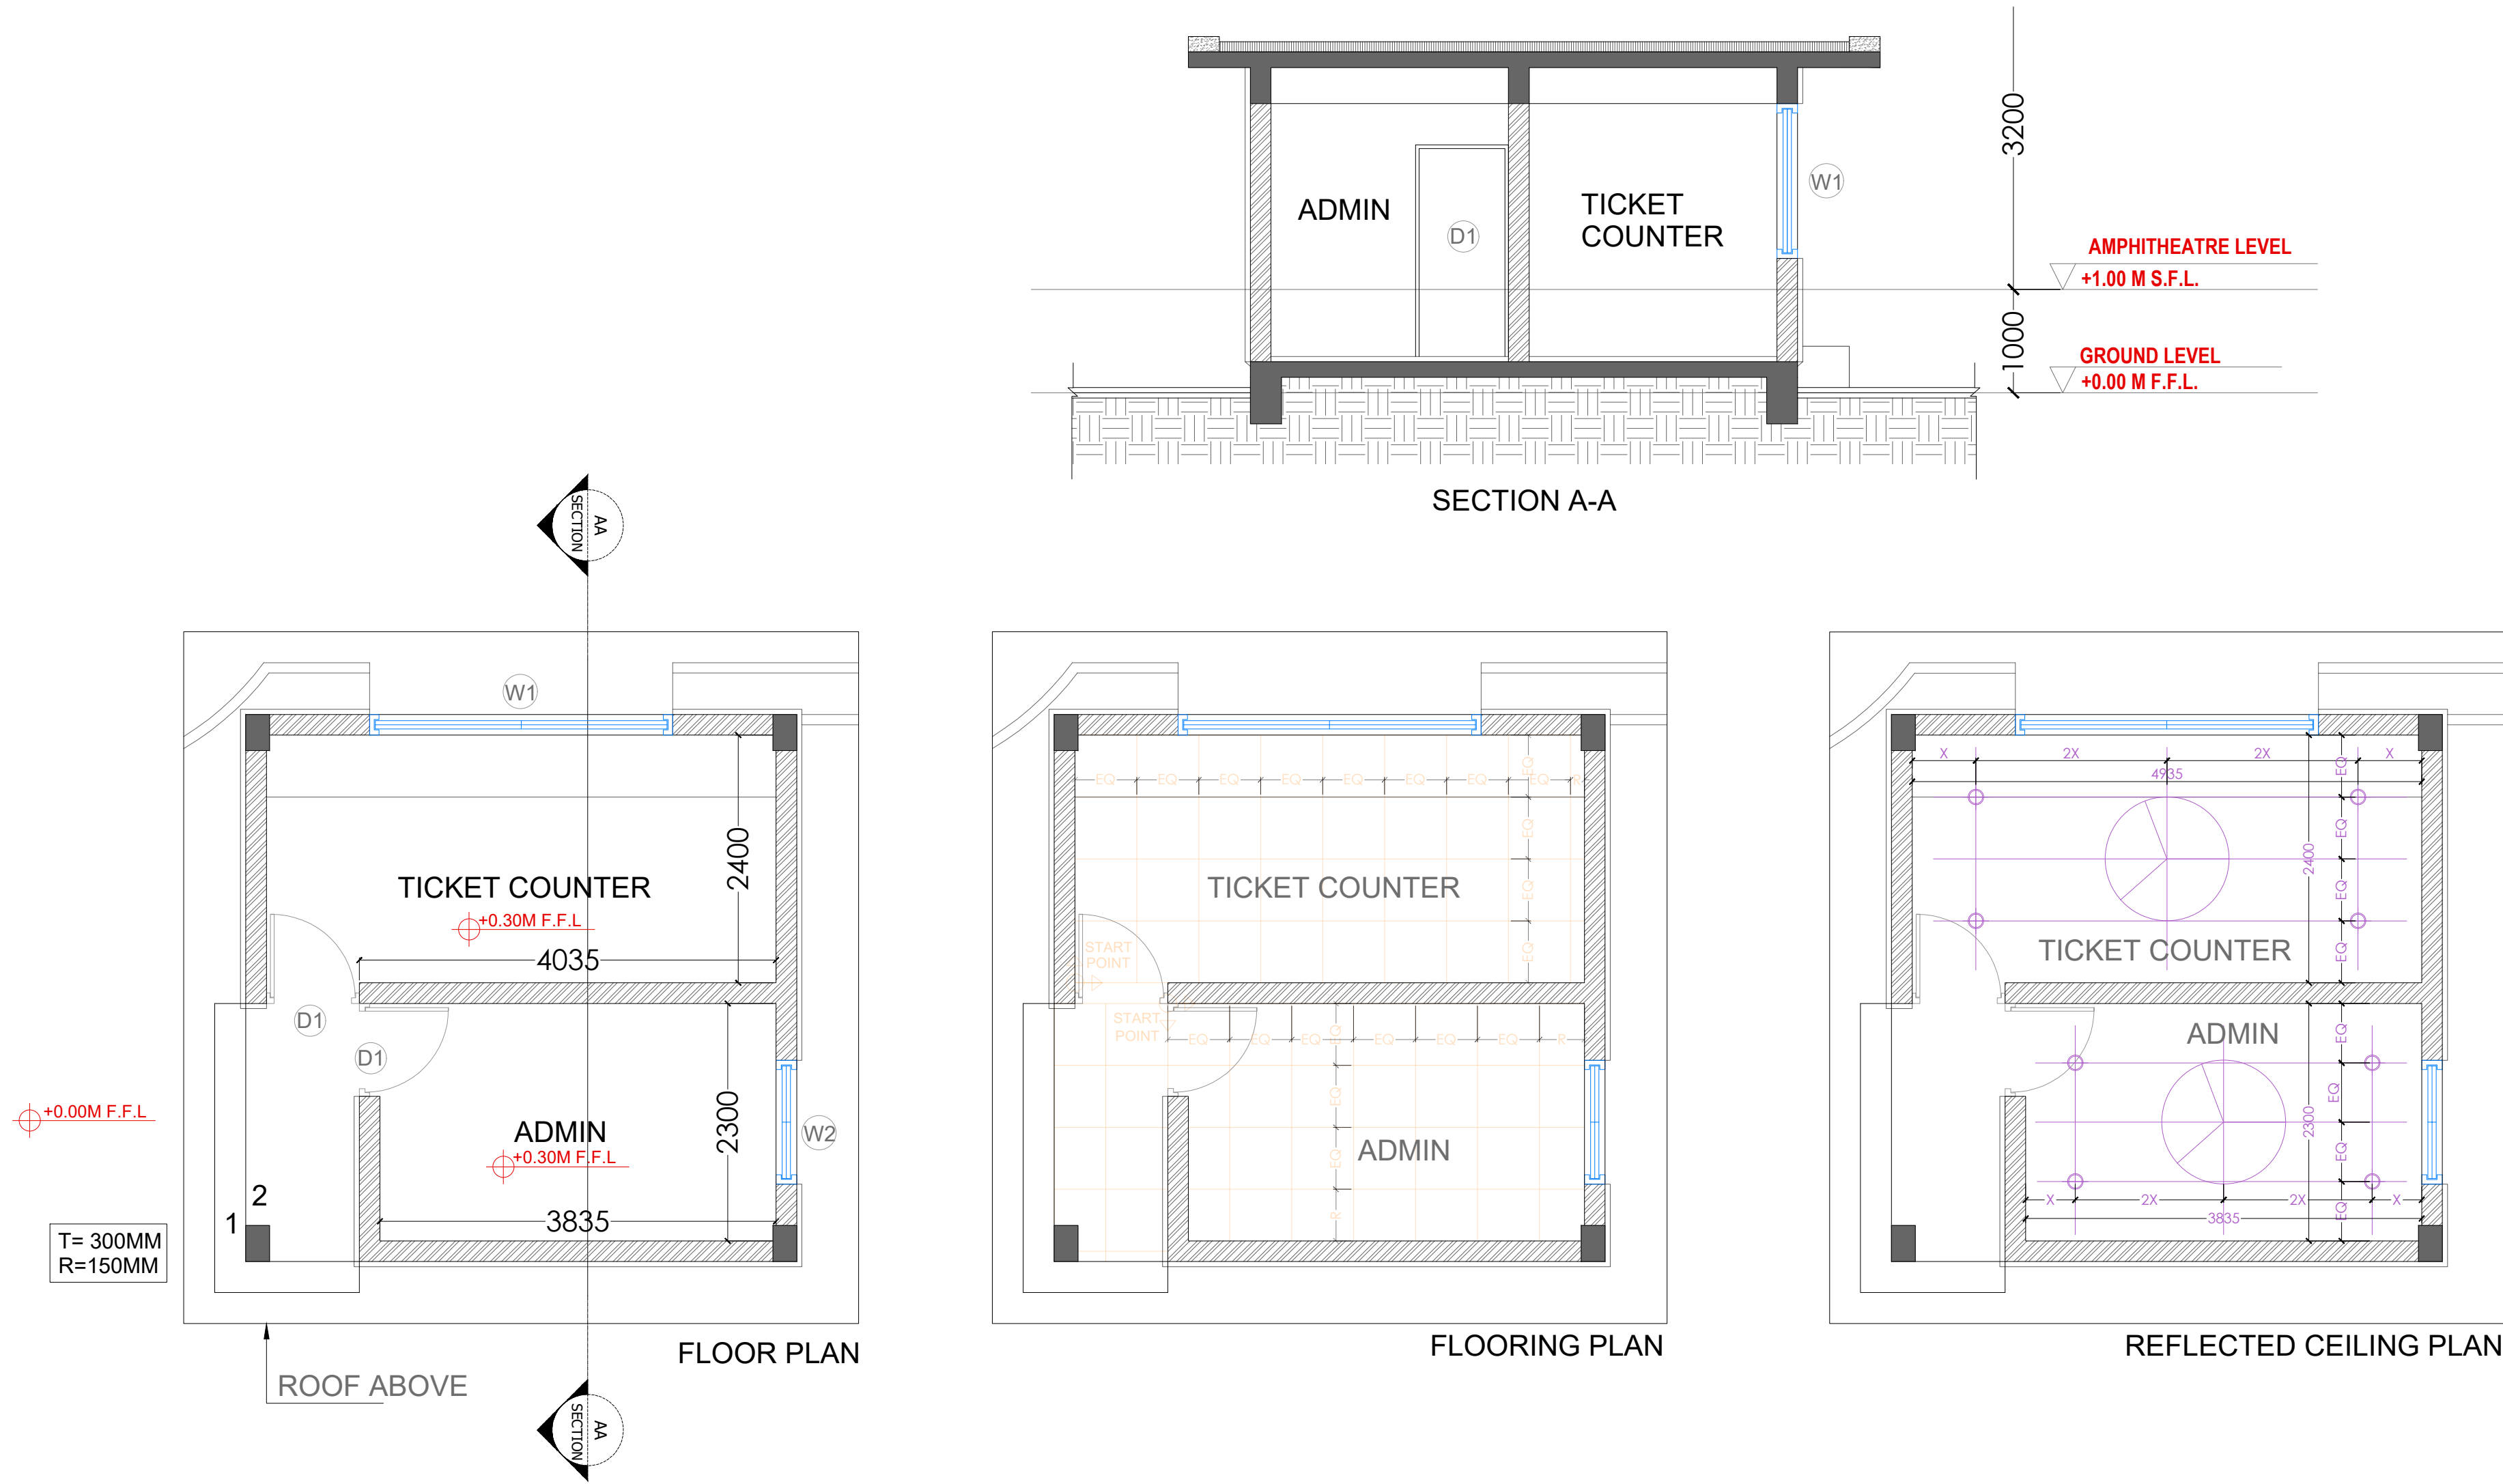


REV NO.	REVISION DETAILS	DATE

REVISION NOTES

CONSULTANTS:


STRUCTURAL CONSULTANT :  **Associated Structural Engineers LLP.**
607, Opal Square, Opp. Palladevi Lake, Barve Rd. Wagale Estate, Thane (w) - 400 604.
Phone: +91-22-25812084/85, 8876072223
Email: info@asc.org.in Website: www.asc.org.in

 MEP CONSULTANT :
M/s. Specialised Mep Engineering Consultants.
Thane - West
Email : specialisedmepconsultants@gmail.com

SCALE: 1:150	DRAWN BY SHRADDHA	
PAPER A2	CHECKED BY KALYANI	
DATE 7-10-2024	DRAWING TYPE : TENDER DRAWING	
DRAWING NAME:	INDEX AND SCHEDULES	
REVISION NUMBER:	R0	
PROJECT NAME:	BAHURATNA VASUNDHARA - GUJARAT UNIVERSITY	
PROJECT NUMBER:		
ARCHITECT:	APICES STUDIO PVT. LTD.	
CLIENT NAME:	GUJARAT UNIVERSITY	



APICES STUDIO PVT. LTD.
203,204,205,LODHA SUPREMUS,
ROAD NO.22,WAGALE ESTATE,
THANE WEST - 400604
TEL: +91 22 25870701/702/703/704

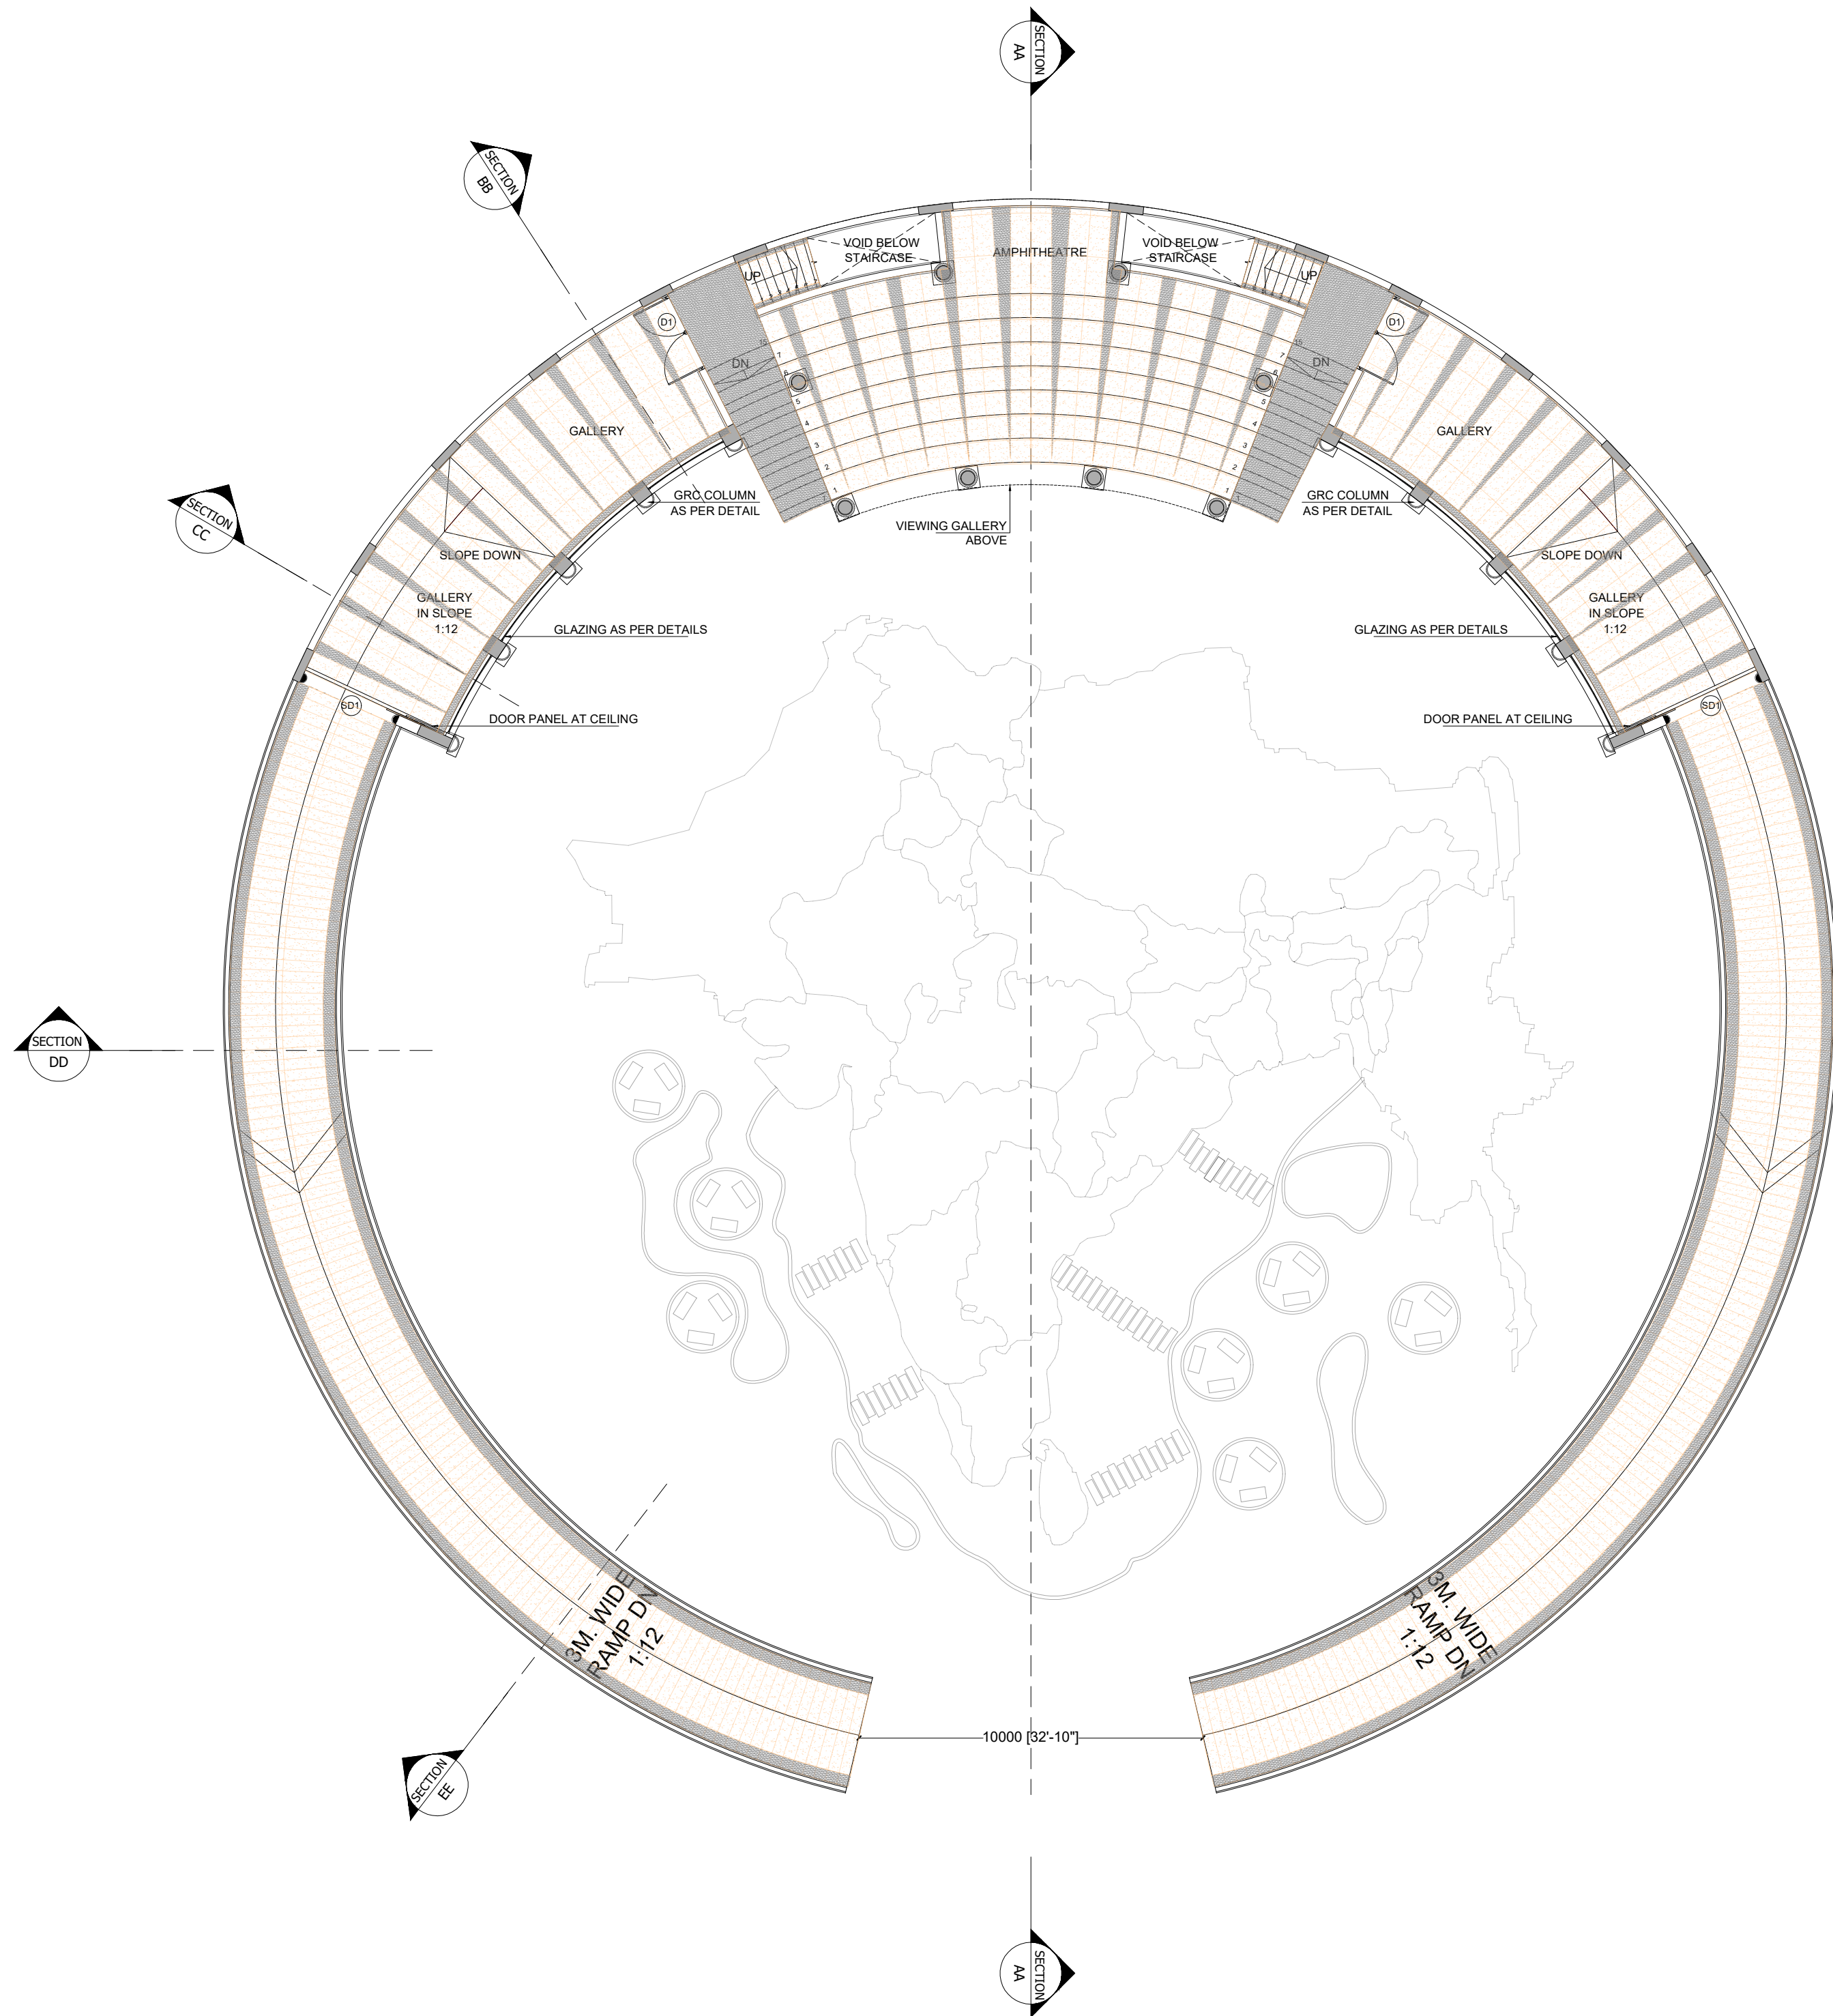

FIRST FLOOR PLAN

APS-BV-A-901-R0

0.0.0

GENERAL NOTES:
ALL DIMENSIONS SHOWN ARE IN MILLIMETERS
ALL SURFACE LEVELS ARE SHOWN IN METERS
THIS DRAWING SHALL NOT BE SCALED.
WRITTEN DIMENSIONS SHALL BE FOLLOWED.

DISCREPANCIES BETWEEN SITE CONDITION AND DATA SHOWN ON DRAWING SHALL BE BROUGHT TO THE NOTICE OF THE ARCHITECT PRIOR TO CONSTRUCTION WORKS.

DRAWING NOTES:
1. THE INFORMATION ON THIS DRAWING SUPERCEDES INFORMATION IN OTHER DRAWINGS.
2. ALL THE EXISTING TREES NEED TO BE RETAIN AND TRIMMED.

KEY PLAN :

REV NO.	REVISION DETAILS	DATE

REVISION NOTES

CONSULTANTS:

STRUCTURAL CONSULTANT :

Associated Structural Engineers LLP.
607, Opal Square, Opp. Ralladevi Lake, Barve Rd. Wagale Estate, Thane (w) - 400 604.
Phone: +91-22-25812084/85, 8976072223
Email: info@asc.org.in Website: www.asc.org.in



MEP CONSULTANT :

M/s. Specialised Mep Engineering Consultants.
Thane - West
Email : specialisedmepconsultants@gmail.com

SCALE: 1:150	DRAWN BY SHRADDHA	
PAPER A2	CHECKED BY KALYANI	
DATE 17-10-2024	DRAWING TYPE : TENDER DRAWING	
DRAWING NAME:	FLOORING PLANS	
REVISION NUMBER:	R0	
PROJECT NAME:	BAHURATNA VASUNDHARA - GUJARAT UNIVERSITY	
PROJECT NUMBER:		
ARCHITECT:	APICES STUDIO PVT. LTD.	
CLIENT NAME:	GUJARAT UNIVERSITY	

PROJECT ARCHITECTS

APICES STUDIO PVT. LTD.
203,204,205,LODHA SUPREMUS,
ROAD NO.22,WAGALE ESTATE,
THANE WEST - 400604
TEL: +91 22 25870701/702/703/704

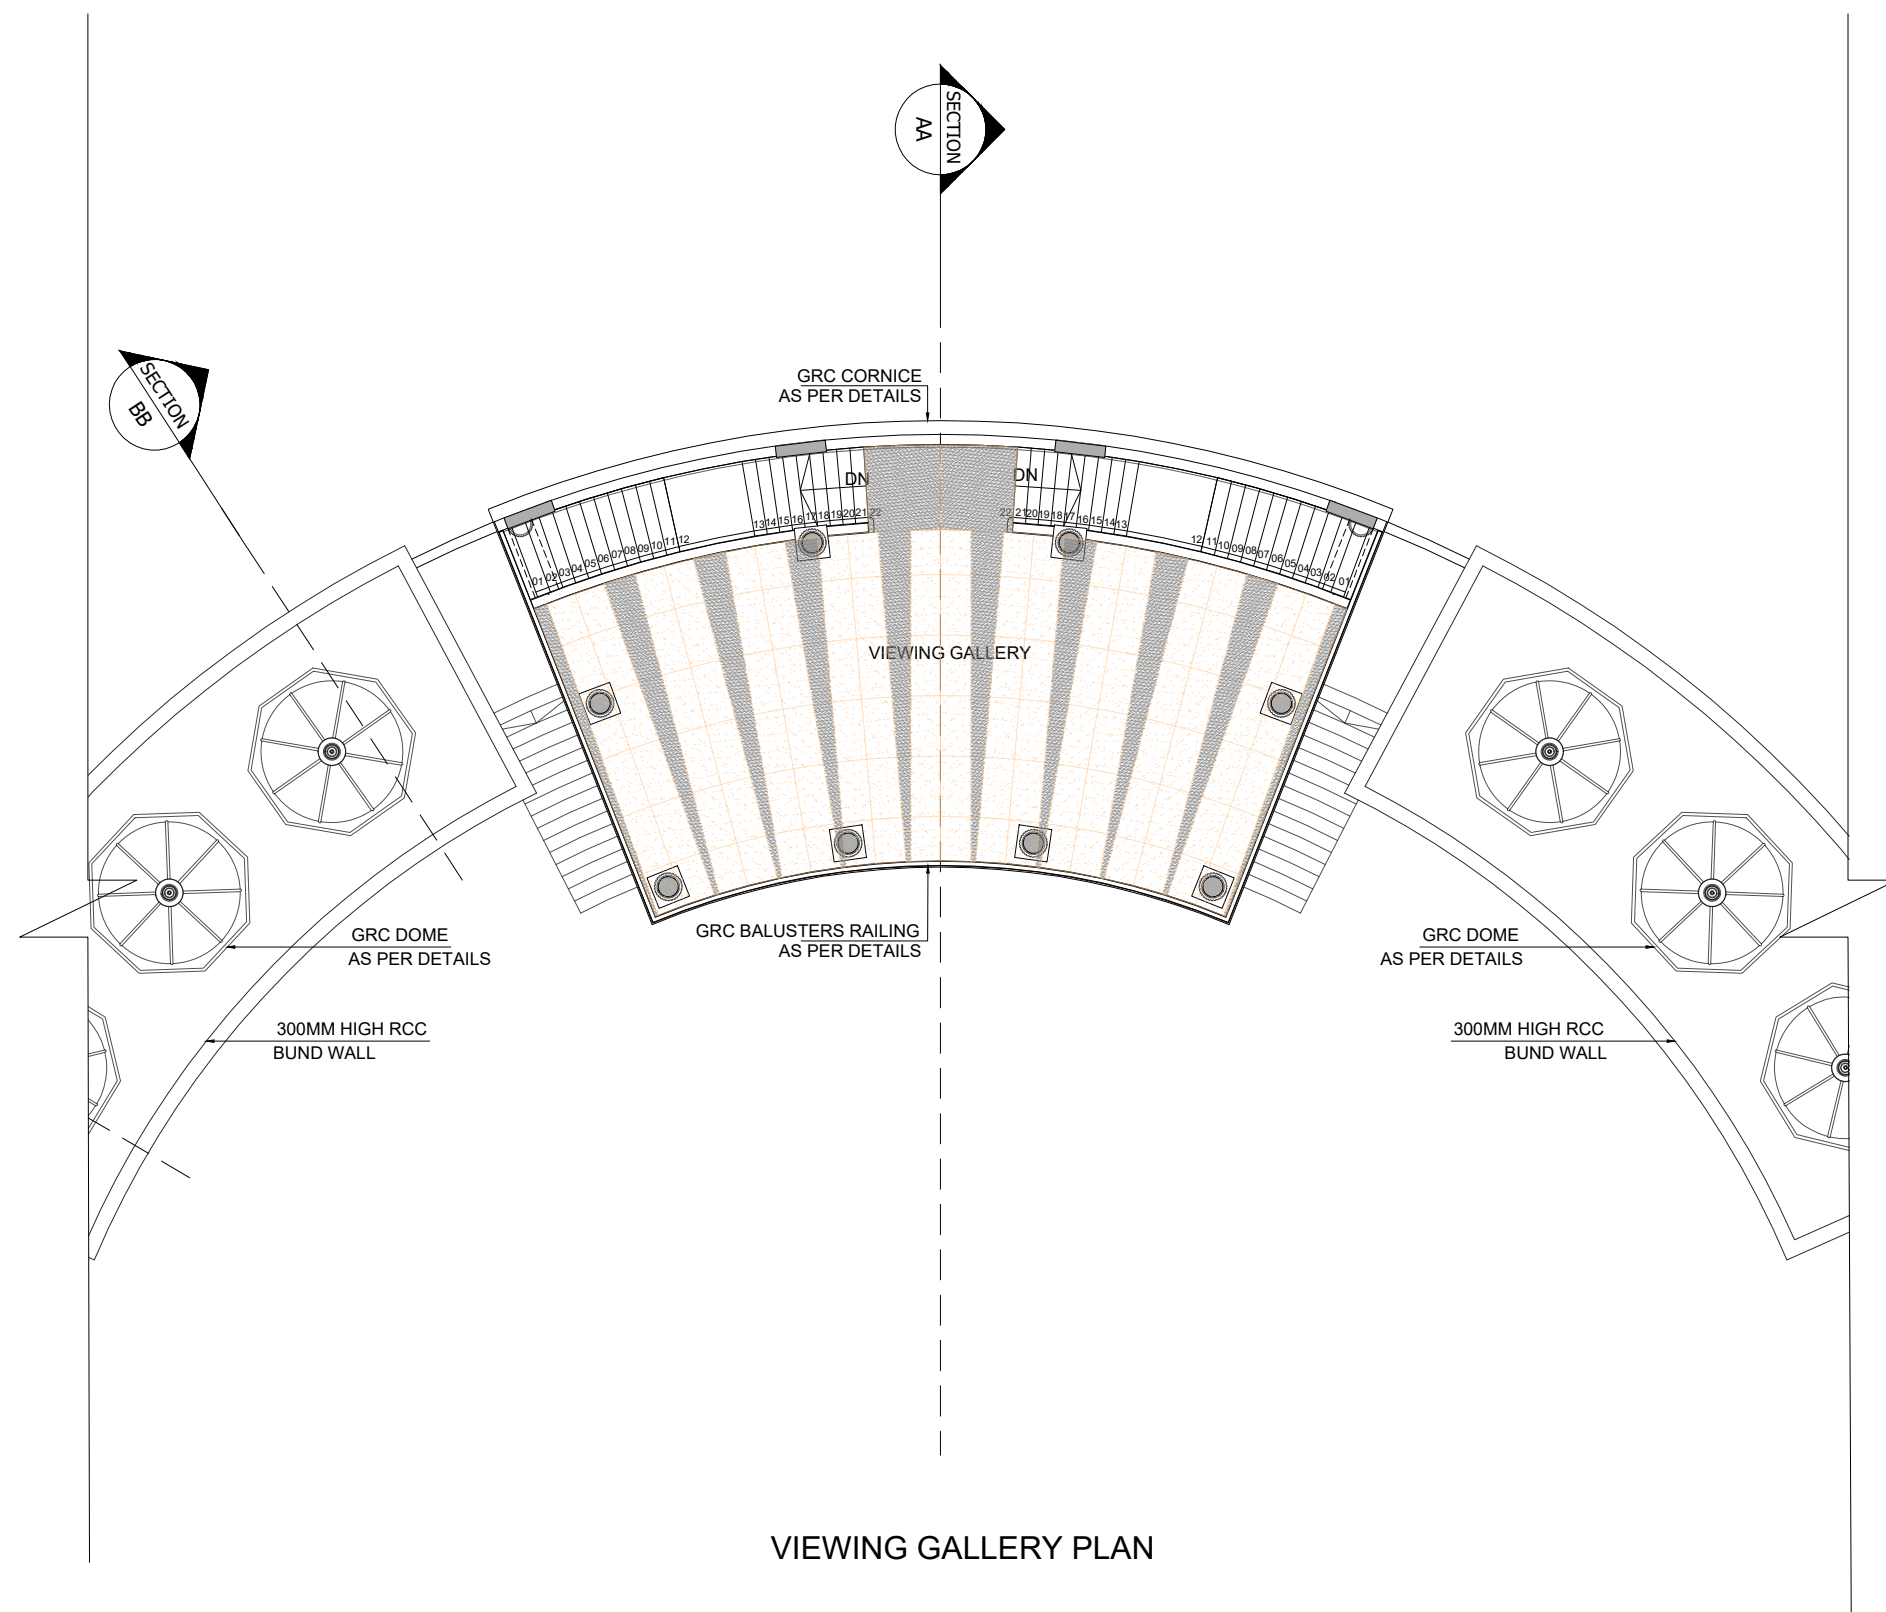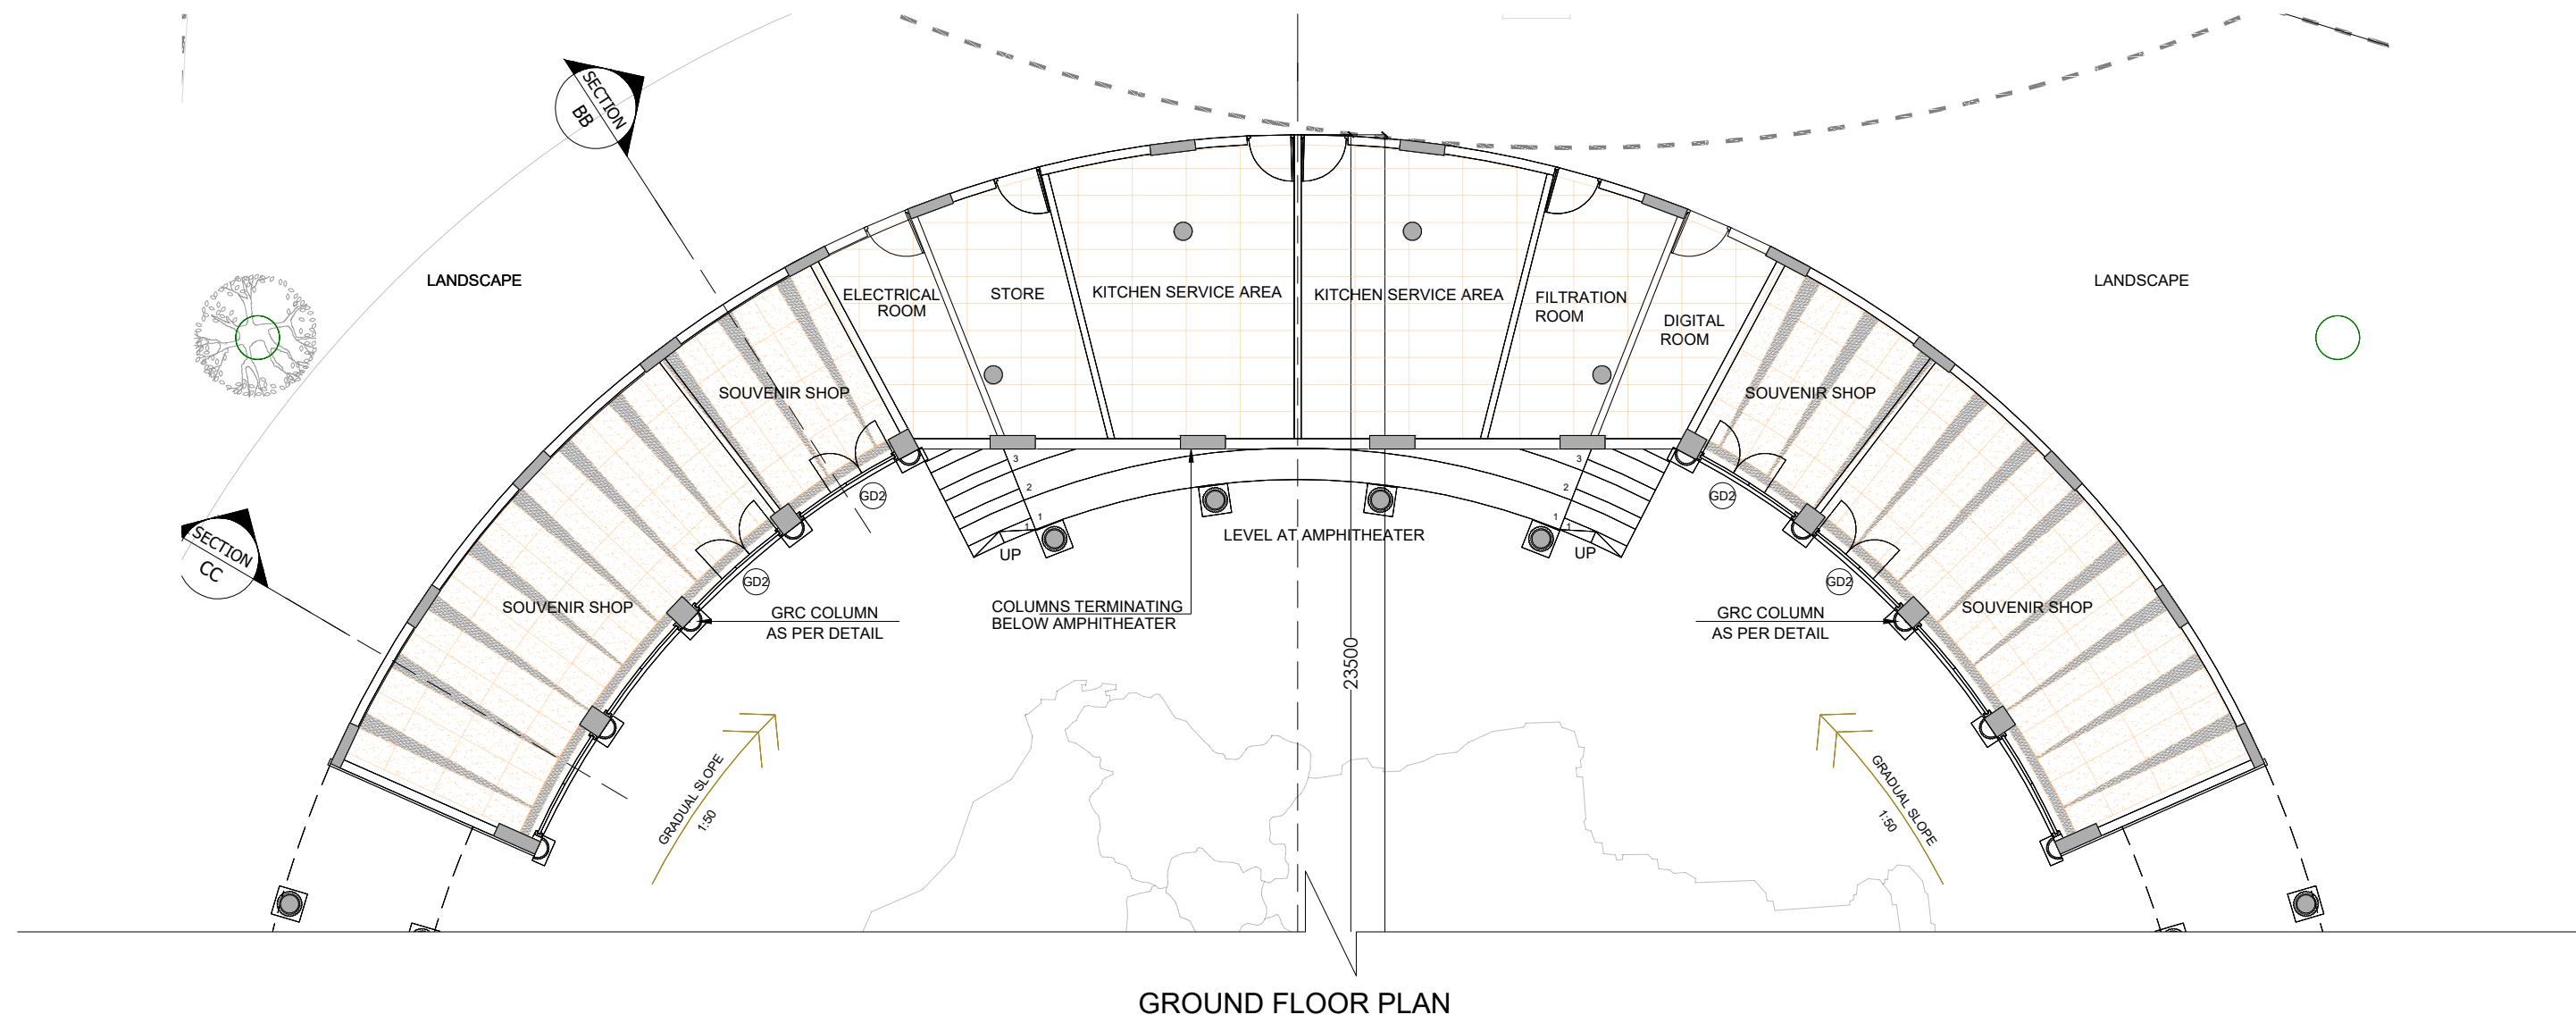

GENERAL NOTES:
ALL DIMENSIONS SHOWN ARE IN MILLIMETERS
ALL SURFACE LEVELS ARE SHOWN IN METERS
THIS DRAWING SHALL NOT BE SCALED.
WRITTEN DIMENSIONS SHALL BE FOLLOWED.

DISCREPANCIES BETWEEN SITE CONDITION AND
DATA SHOWN ON DRAWING SHALL BE
BROUGHT TO THE NOTICE OF THE ARCHITECT
PRIOR TO CONSTRUCTION WORKS.

DRAWING NOTES:
1. THE INFORMATION ON THIS DRAWING
SUPERCEDES INFORMATION IN OTHER DRAWINGS.
2. ALL THE EXISTING TREES NEED TO BE RETAIN AND
TRIMMED.

KEY PLAN :


REV NO.	REVISION DETAILS	DATE
---------	------------------	------

REVISION NOTES

CONSULTANTS:

STRUCTURAL
CONSULTANT :  Associated Structural
Engineers LLP.
607, Opal Square, Opp. Ralladevi Lake, Barve Rd. Wagale Estate,
Thane (w) - 400 604.
Phone: +91-22-25812084/85, 8876072223
Email: info@asc.org.in Website: www.asc.org.in

 MEP
CONSULTANT :
M/s. Specialised Mep
Engineering Consultants.
Thane - West
Email : specialisedmepconsultants@gmail.com

SCALE: 1:150	DRAWN BY SHRADDHA		
PAPER A2	CHECKED BY KALYANI		
DATE 7-10-2024	DRAWING TYPE : TENDER DRAWING		
DRAWING NAME:	FLOORING PLANS		
REVISION NUMBER:	R0		
PROJECT NAME:	BAHURATNA VASUNDHARA - GUJARAT UNIVERSITY		
PROJECT NUMBER:			
ARCHITECT:	APICES STUDIO PVT. LTD.		
CLIENT NAME:	GUJARAT UNIVERSITY		

PROJECT ARCHITECTS



APICES STUDIO PVT. LTD.
203,204,205,LODHA SUPREMUS,
ROAD NO.22,WAGALE ESTATE,
THANE WEST - 400604
TEL: +91 22 25870701/702/703/704